

Structural Engineer
WSP
Tel: 207 337 1700

MEP Engineer
Hilson Moran
Tel: 207 940 8888

Landscape Consultant (Strategy)
Arup
Tel: 207 636 1531


Landscape Consultant (Design)
Andy Sturgeon
Tel: 127 367 2575

Structural Engineer (Building F)
AKT II
Tel: 207 250 7777

NOTE: THE DETAILED DESIGN OF THE RESIDENT'S COMMUNAL GARDENS ARE SHOWN FOR ILLUSTRATIVE PURPOSES ONLY

B	ADDENDUM	04.06.
A	ADDENDUM	19.01.
No.	Issue	Check Date

Key Pla

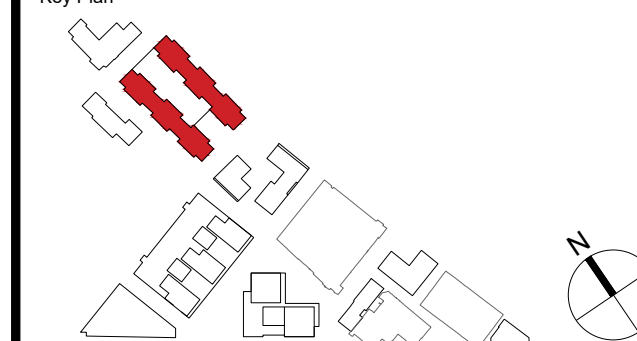

**Kohn Pedersen Fox Associates
(International) PA**
Architects and Planning Consultants

7a Langley Street
London WC2H 9JA
England
T: +44 (0) 20 3119 5300
F: +44 (0) 20 7497 1175
<http://www.kpf.com>

Proj. No.	Project
2607	Bermondsey Project

Scale	Drawn by	Checked by
1:200 @ A1	GG	

Drawing Title and No


LEVEL 01 FLOOR PLAN

PROPOSED

Drawing Ref.
2607-KPF-BC03-01-DR-PLN-

A-0102

E

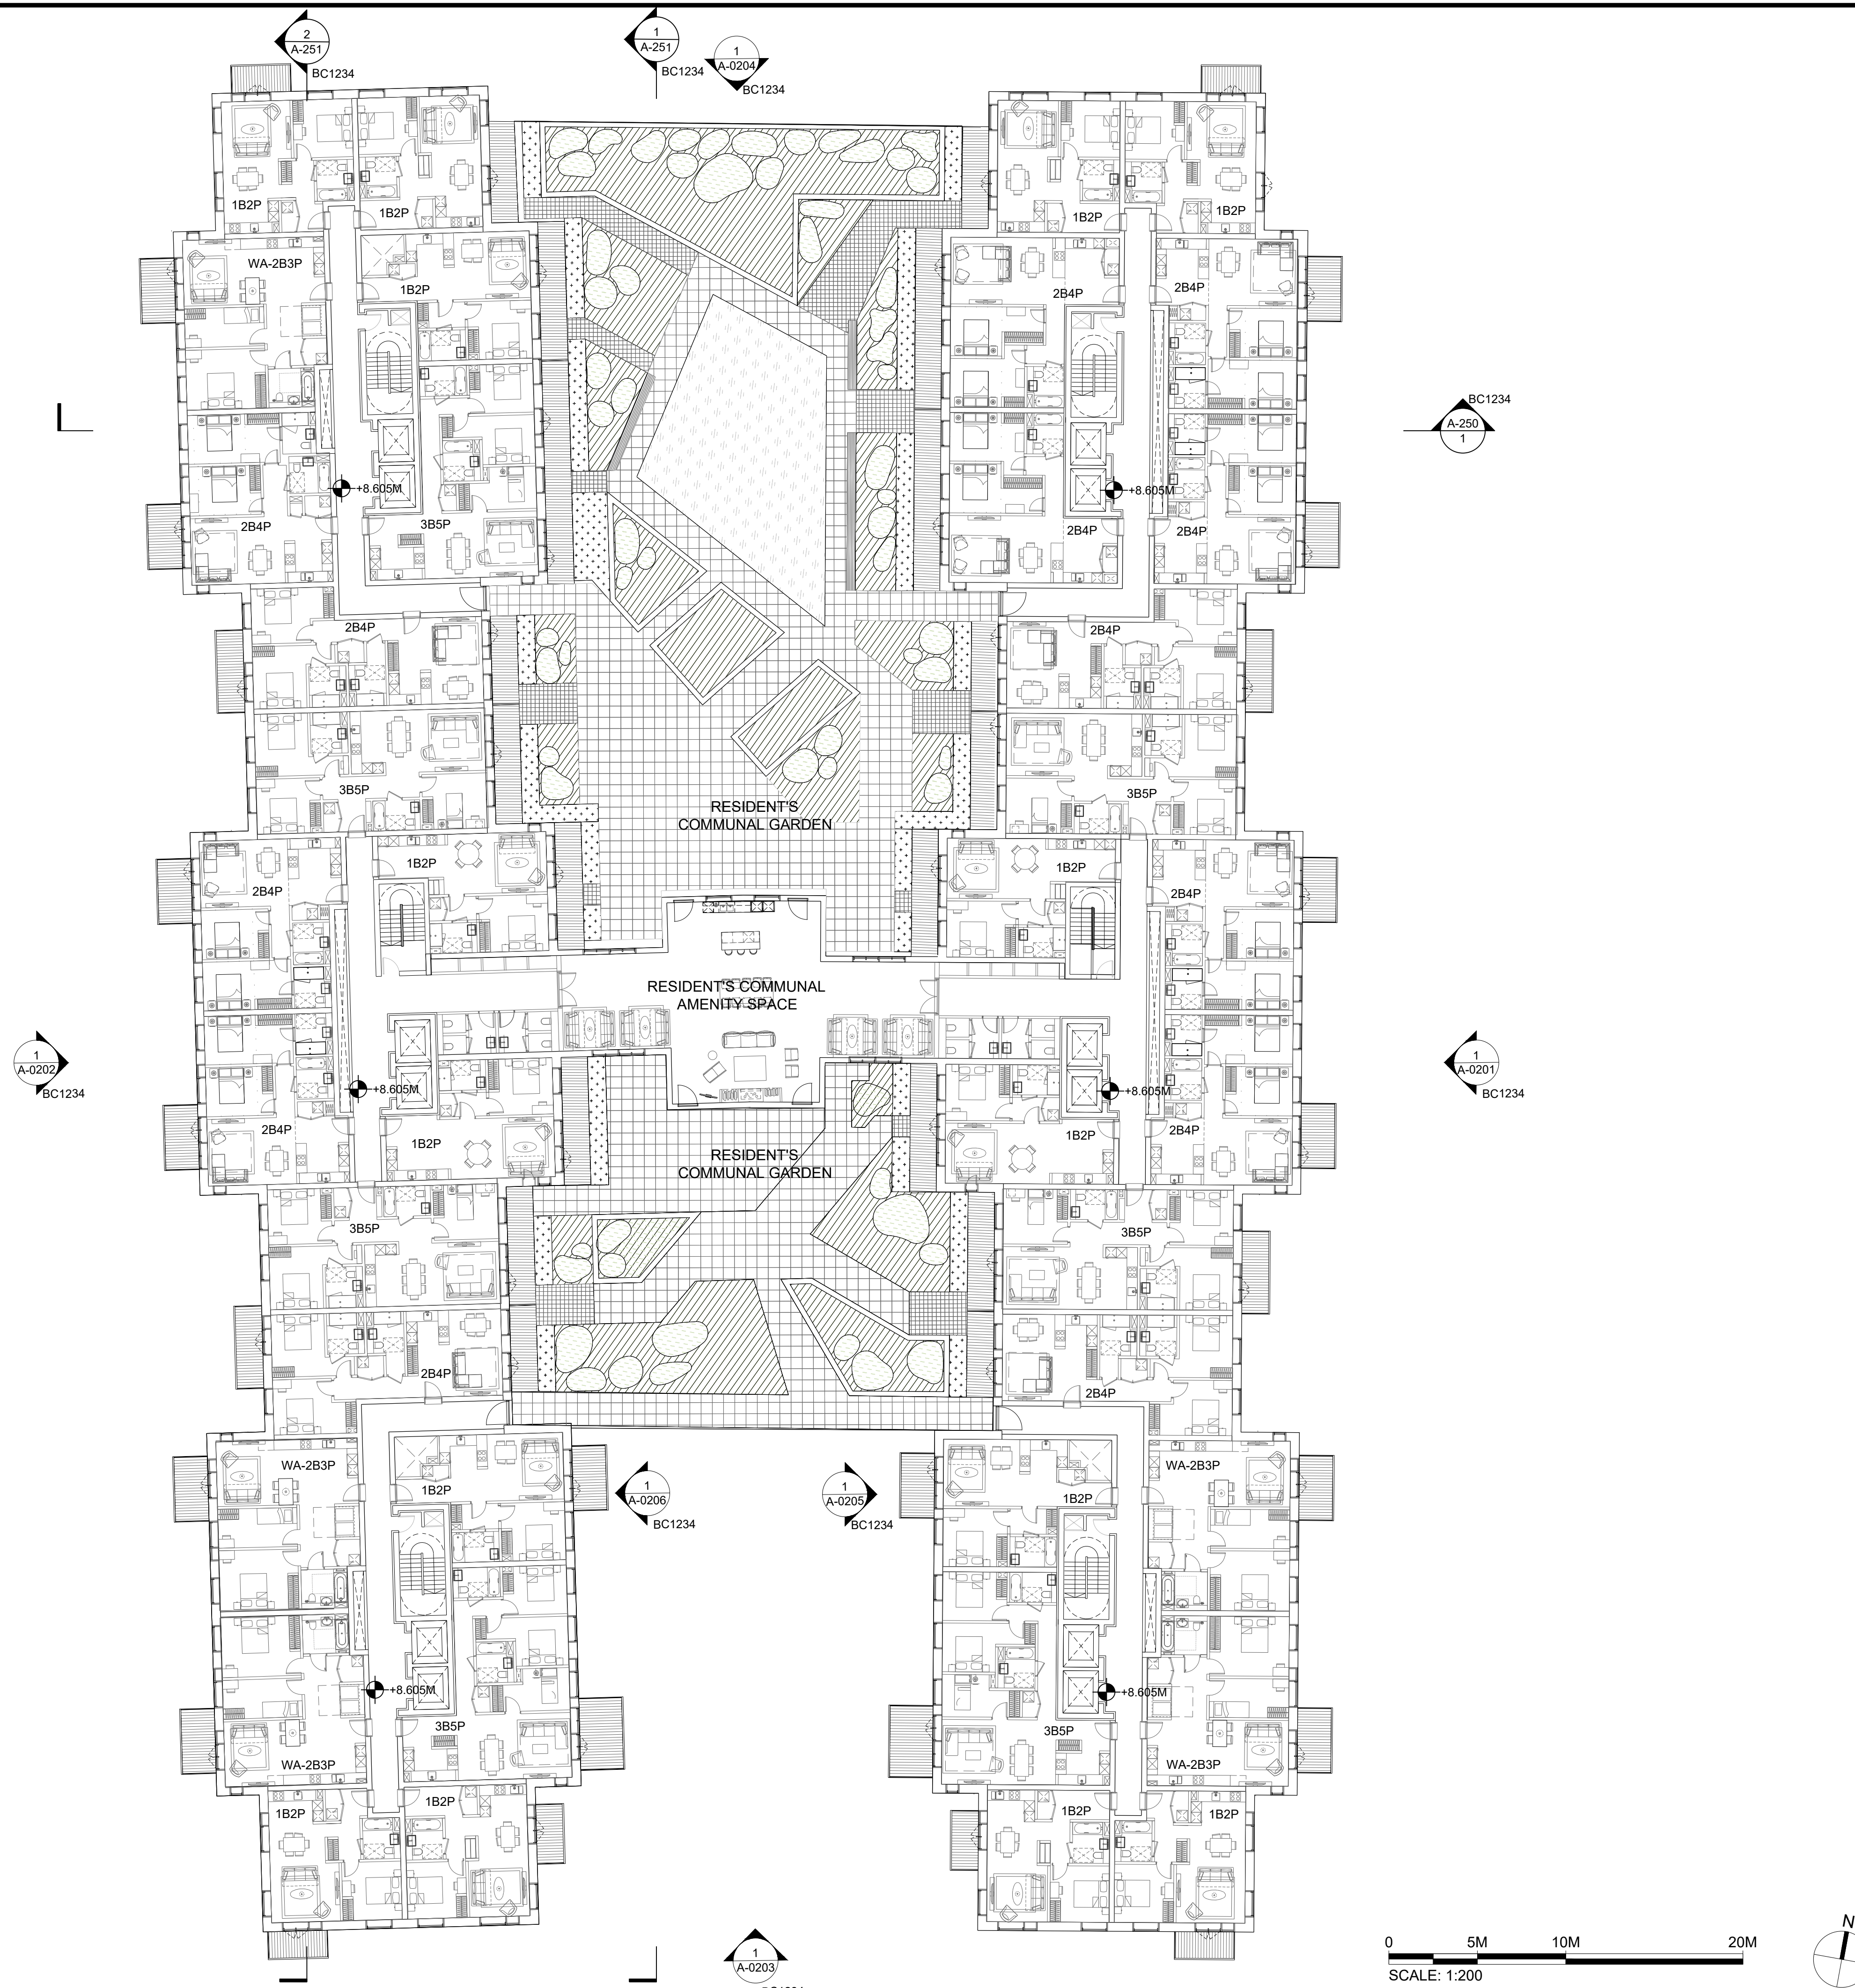

BC-1234
LEVEL 01 FLOOR PLAN
SCALE: 1:200 @ A1