


Filename: H:\2607\_Project\Sunbeam\Drawings\CAD\Sheet\2607-KPF-BC03-02-DR-PLN-A-0103.dwg Plotted by: Slop Magdalena Plot Time: 5/31/2018 7:03 PM

1 LEVEL 02 FLOOR PLAN

SCALE: 1:200 @ A1

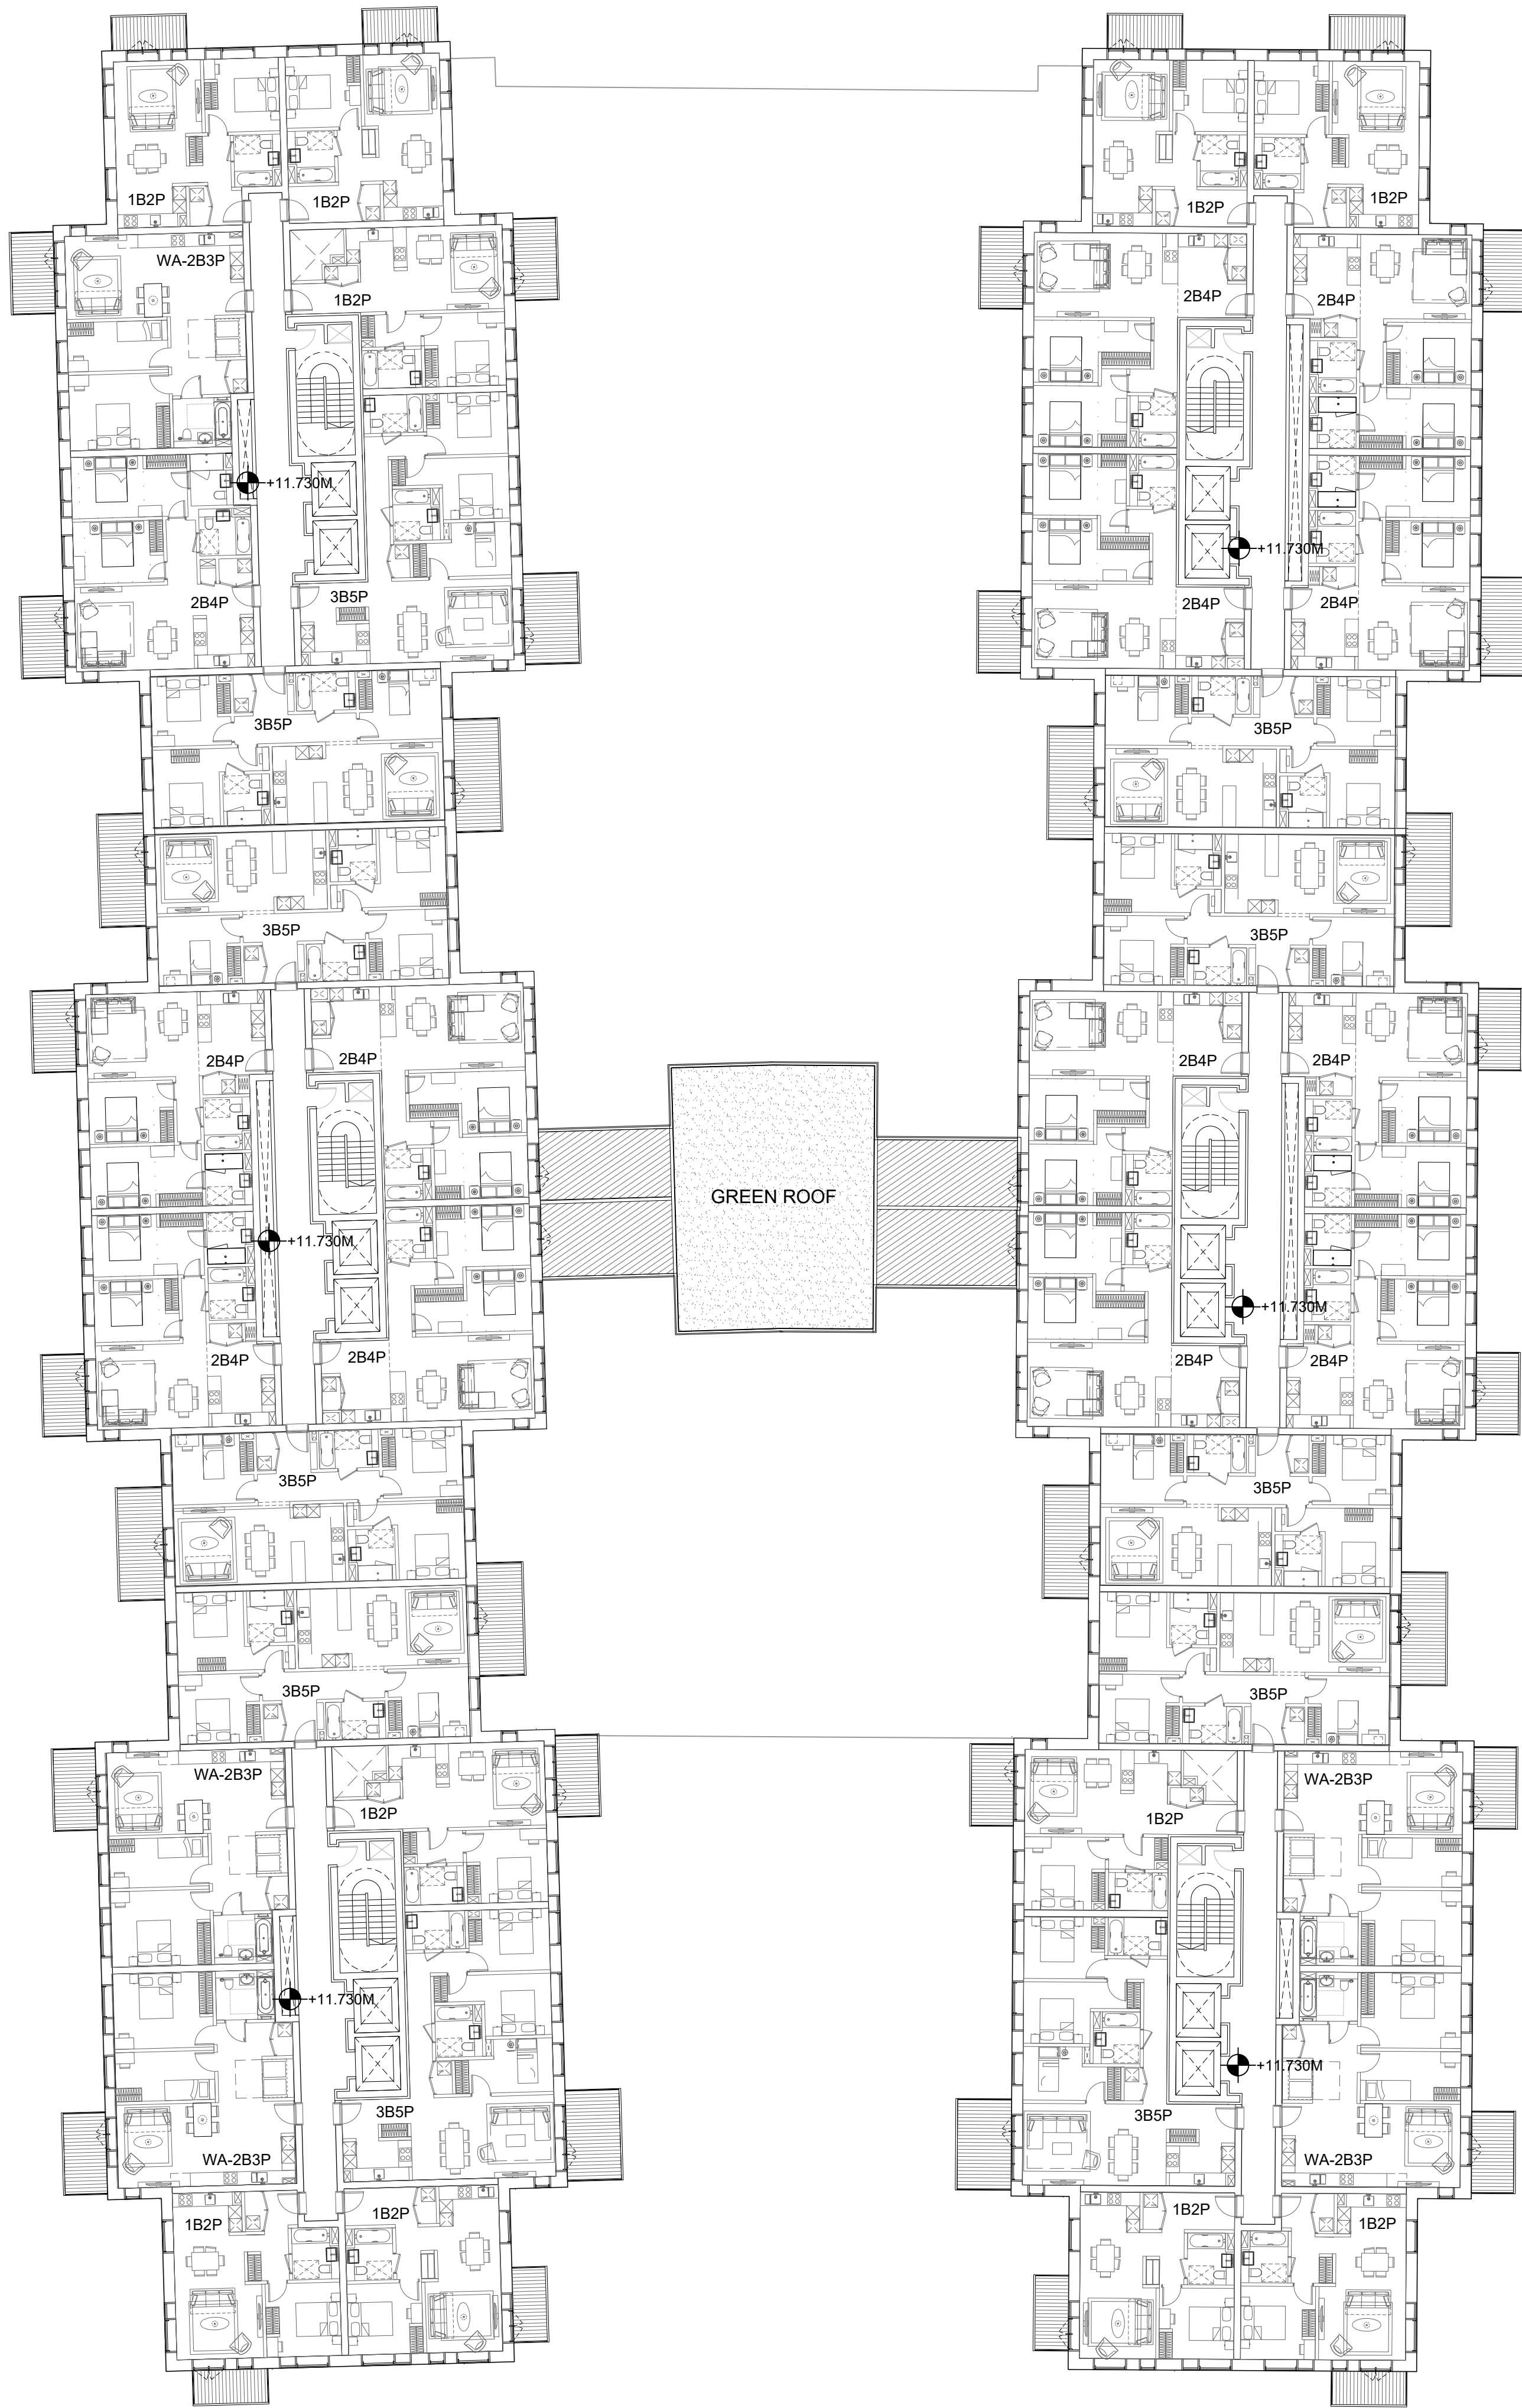

KPF

**Client**  
Southwark GP Nominee 1 Ltd. and  
Southwark GP Nominee 2 Ltd.

**Structural Engineer**  
WSP  
Tel: 207 337 1700


**MEP Engineer**  
Hilson Moran  
Tel: 207 940 8888

**Landscape Consultant (Strategy)**  
Arup  
Tel: 207 636 1531

**Landscape Consultant (Design)**  
Andy Sturgeon  
Tel: 127 367 2575

**Structural Engineer (Building F)**  
AKT II  
Tel: 207 250 7777

B	ADDENDUM	04.06.18
A	ADDENDUM	19.01.18
No.	Issue	Check Date

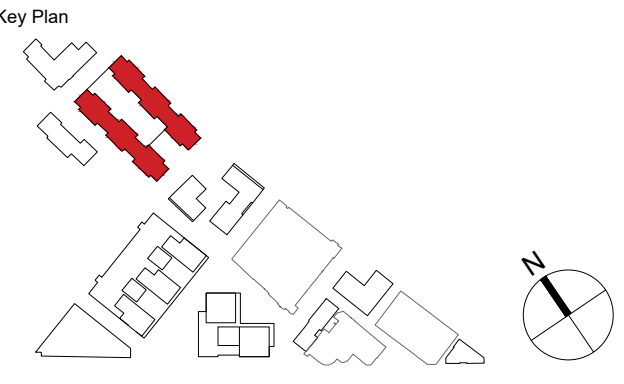

**Kohn Pedersen Fox Associates  
(International) PA**  
Architects and Planning Consultants

7a Langley Street  
London WC2H 9JA  
England  
T: +44 (0) 20 3119 5300  
F: +44 (0) 20 7497 1175  
<http://www.kpf.com>

Proj. No. Project  
**2607 Bermondsey Project**

Scale Drawn by Checked by  
1:200 @ A1 GG

Drawing Title and No.  
LEVEL 02 FLOOR PLAN

Drawing Ref. Rev.  
2607-KPF-BC03-02-DR-PLN-  
**A-0103** **B**