
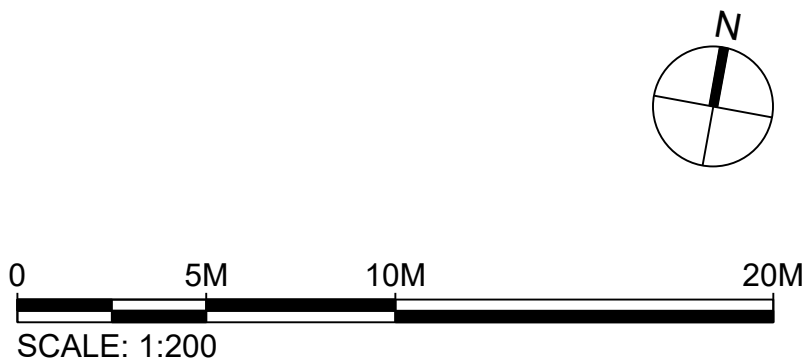


Filename: H:\2607_Project\Sunbeam\Drawings\CAD\Sheet\2607-KPF-BC03-03-DR-PLN-A-0104.dwg Plotted by: Slop, Magdalena Plot Time: 5/31/2018 7:07 PM

1

BC-1234
LEVEL 03 FLOOR PLAN
SCALE: 1:200 @ A1

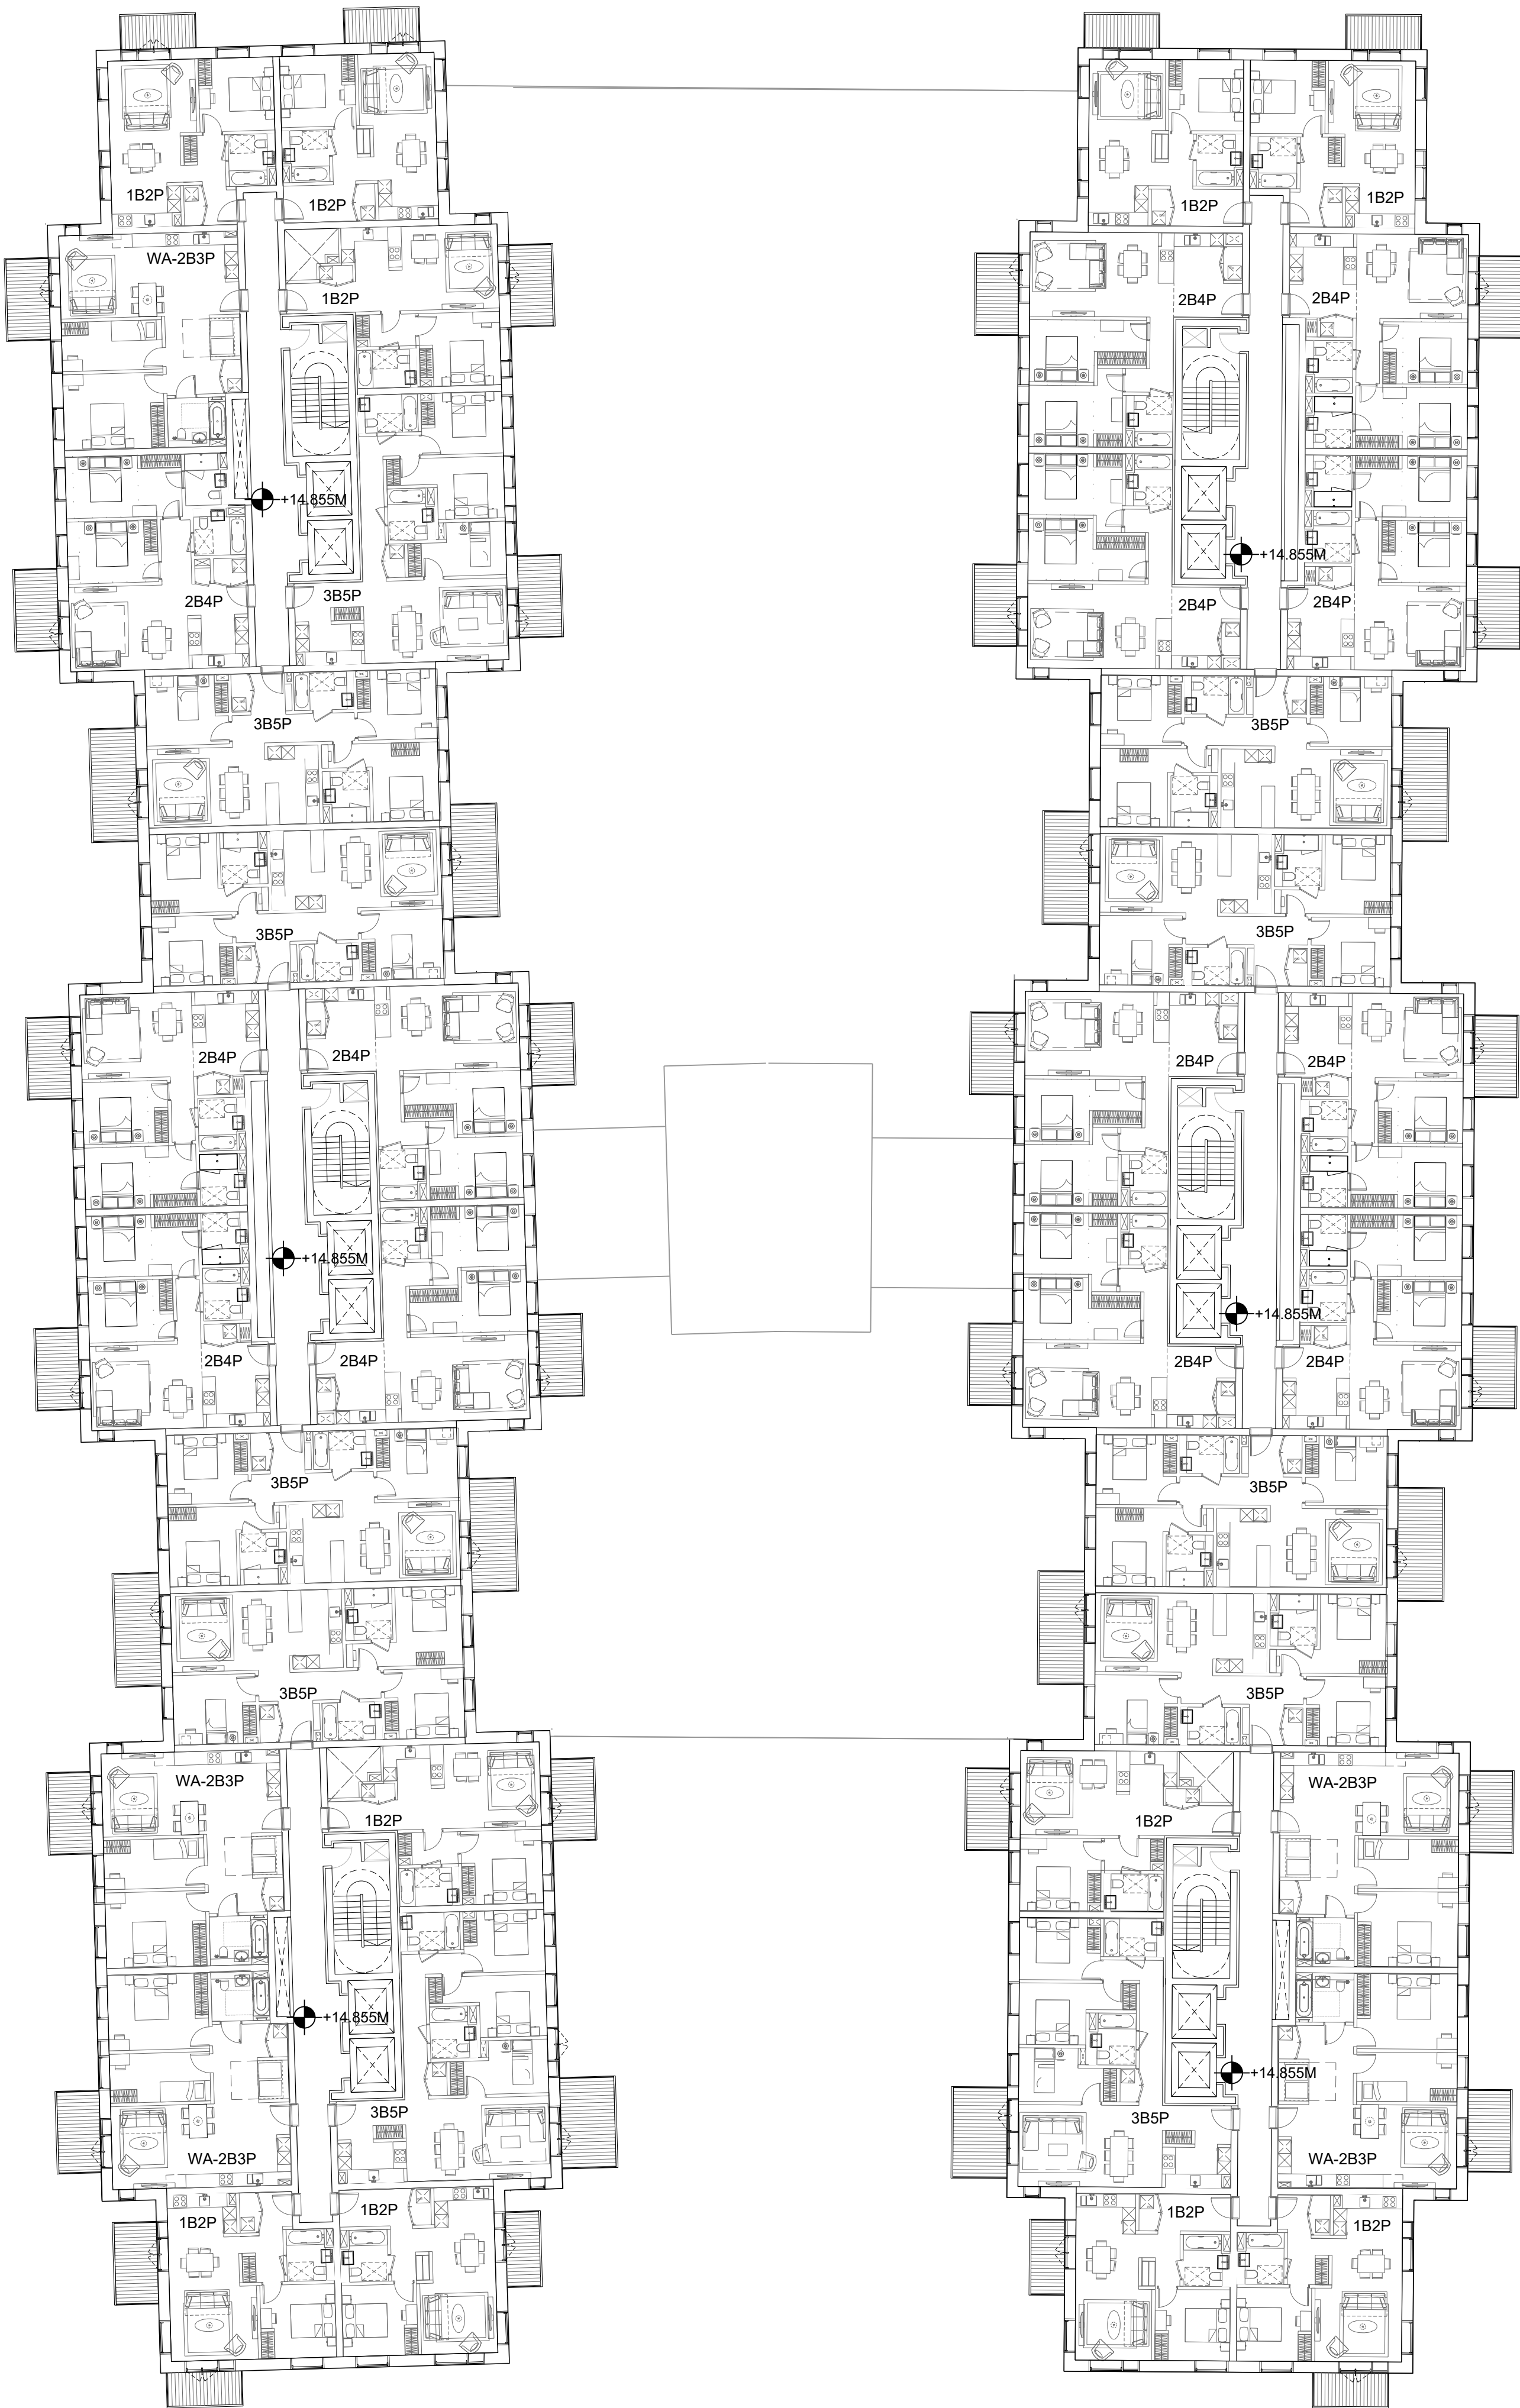

KPF

Client
Southwark GP Nominee 1 Ltd. and
Southwark GP Nominee 2 Ltd.

Structural Engineer
WSP
Tel: 207 337 1700


MEP Engineer
Hilson Moran
Tel: 207 940 8888

Landscape Consultant (Strategy)
Arup
Tel: 207 636 1531

Landscape Consultant (Design)
Andy Sturgeon
Tel: 127 367 2575

Structural Engineer (Building F)
AKT II
Tel: 207 250 7777

B	ADDENDUM	04.06.18
A	ADDENDUM	19.01.18
No.	Issue	Check Date

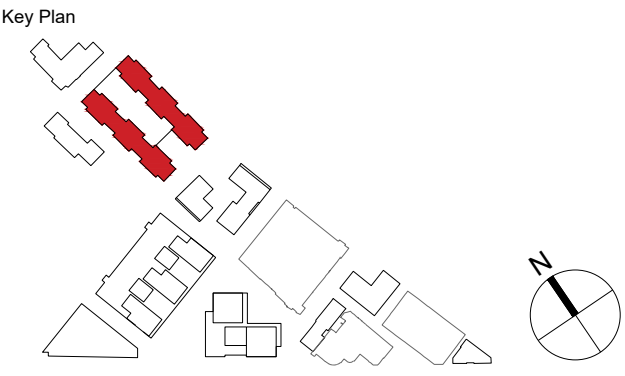

**Kohn Pedersen Fox Associates
(International) PA**
Architects and Planning Consultants

7a Langley Street
London WC2H 9JA
England
T: +44 (0) 20 3119 5300
F: +44 (0) 20 7497 1175
<http://www.kpf.com>

Proj. No.	Project	
2607	Bermondsey Project	
Scale	Drawn by	Checked by
1:200 @ A1	GG	
Drawing Title and No.		
BC-1234		
LEVEL 03 FLOOR PLAN		
PROPOSED		
Drawing Ref.	Rev.	
2607-KPF-BC03-03-DR-PLN-		
A-0104	B	