
 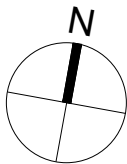



Filename: H:\2607_Project\Sunbeam\Drawings\CAD\Sheet\2607-KPF-BC03-04-DR-PLN-A-0105.dwg Plotted by: Slop Magdalena Plot Time: 5/31/2018 9:22 PM

1

BC-1234
LEVEL 04 FLOOR PLAN
SCALE: 1:200 @ A1

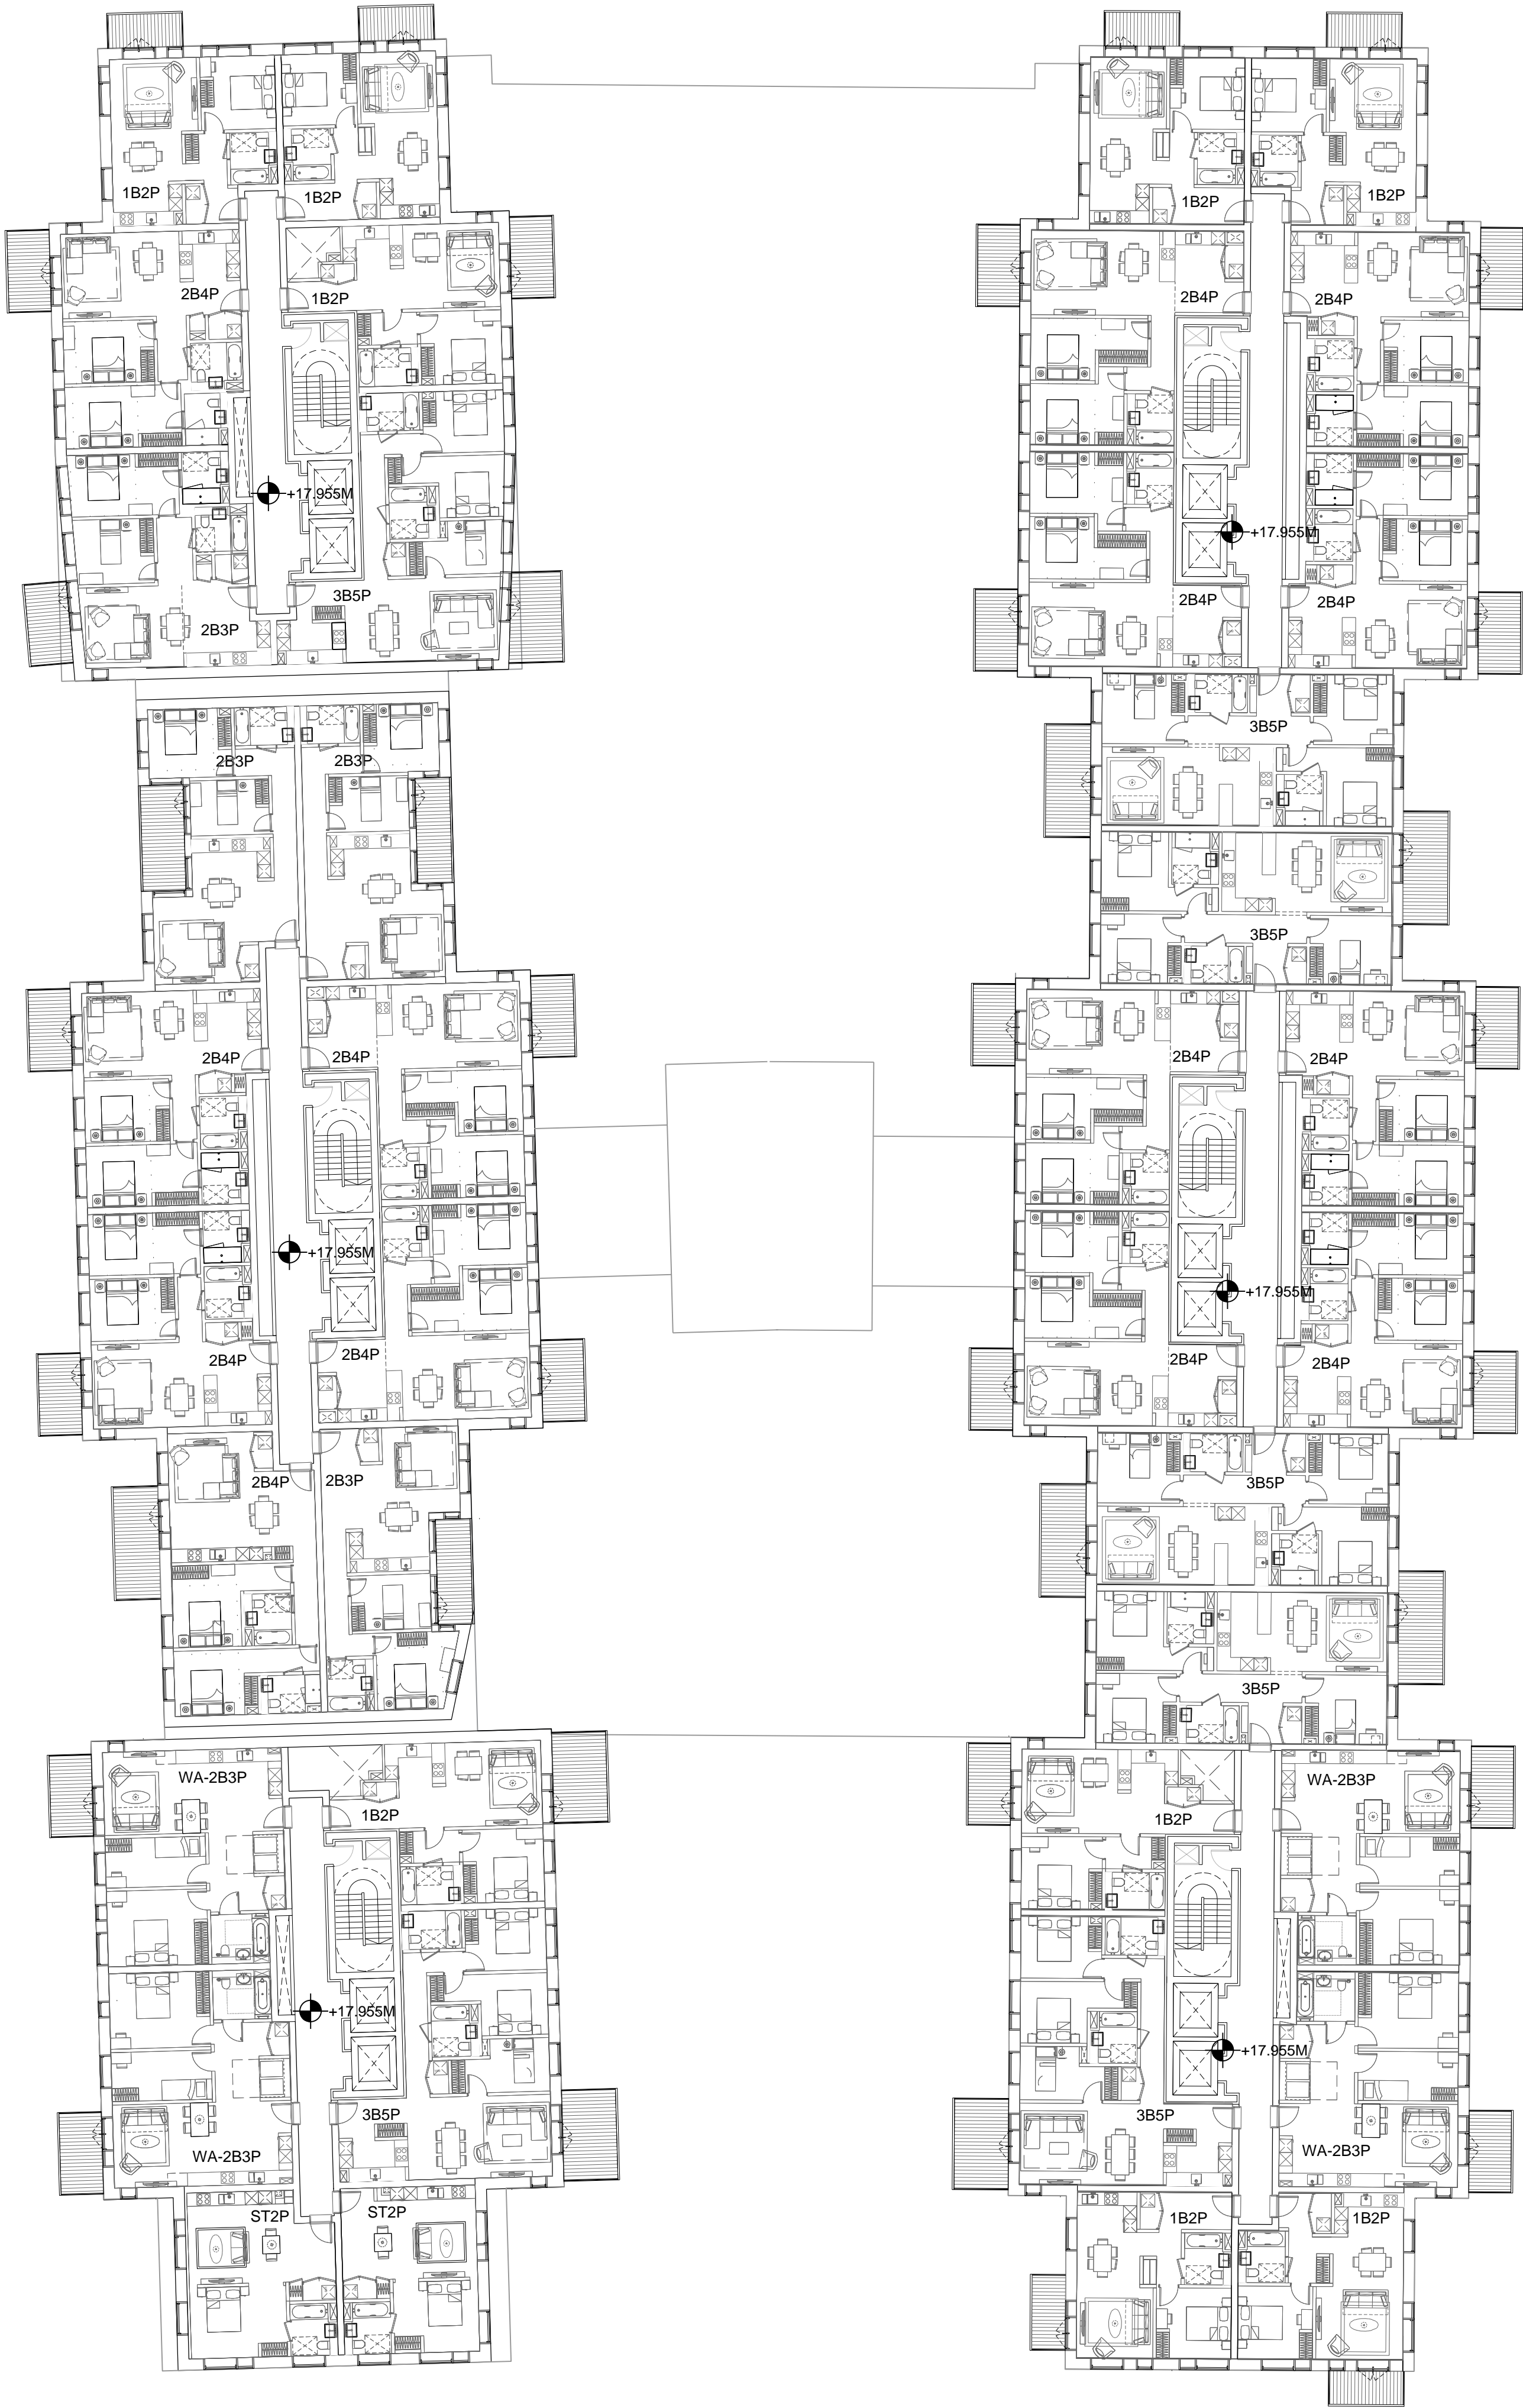

KPF

Client

Southwark GP Nominee 1 Ltd. and
Southwark GP Nominee 2 Ltd.

Structural Engineer

WSP
Tel: 207 337 1700

MEP Engineer

Hilson Moran
Tel: 207 940 8888

Landscape Consultant (Strategy)

Arup
Tel: 207 636 1531


Landscape Consultant (Design)

Andy Sturgeon
Tel: 127 367 2575

Structural Engineer (Building F)

AKT II
Tel: 207 250 7777

A ADDENDUM				04.06.18
No.	Issue	Check	Date	

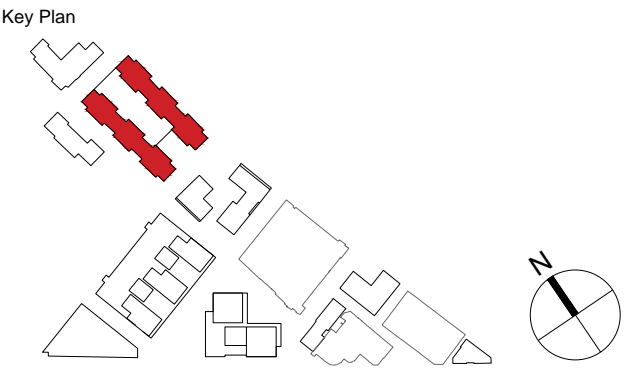

**Kohn Pedersen Fox Associates
(International) PA**
Architects and Planning Consultants

7a Langley Street
London WC2H 9JA
England
T: +44 (0) 20 3119 5300
F: +44 (0) 20 7497 1175
<http://www.kpf.com>

Proj. No. Project
2607 Bermondsey Project

Scale Drawn by Checked by
1:200 @ A1 GG

Drawing Title and No.

BC-1234

LEVEL 04 FLOOR PLAN

PROPOSED

Drawing Ref.

2607-KPF-BC03-04-DR-PLN-

A-0105

A