
 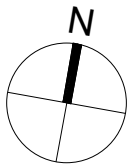



Filename: H:\2607\_Project\Sunbeam\Drawings\CAD\Sheet\2607-KPF-BC03-07-DR-PLN-A-0108.dwg Plotted by: Grauvogel, Guillermo Plot Time: 10/20/2017 4:03 PM

1

BC-1234  
LEVEL 07 FLOOR PLAN  
SCALE: 1:200 @ A1

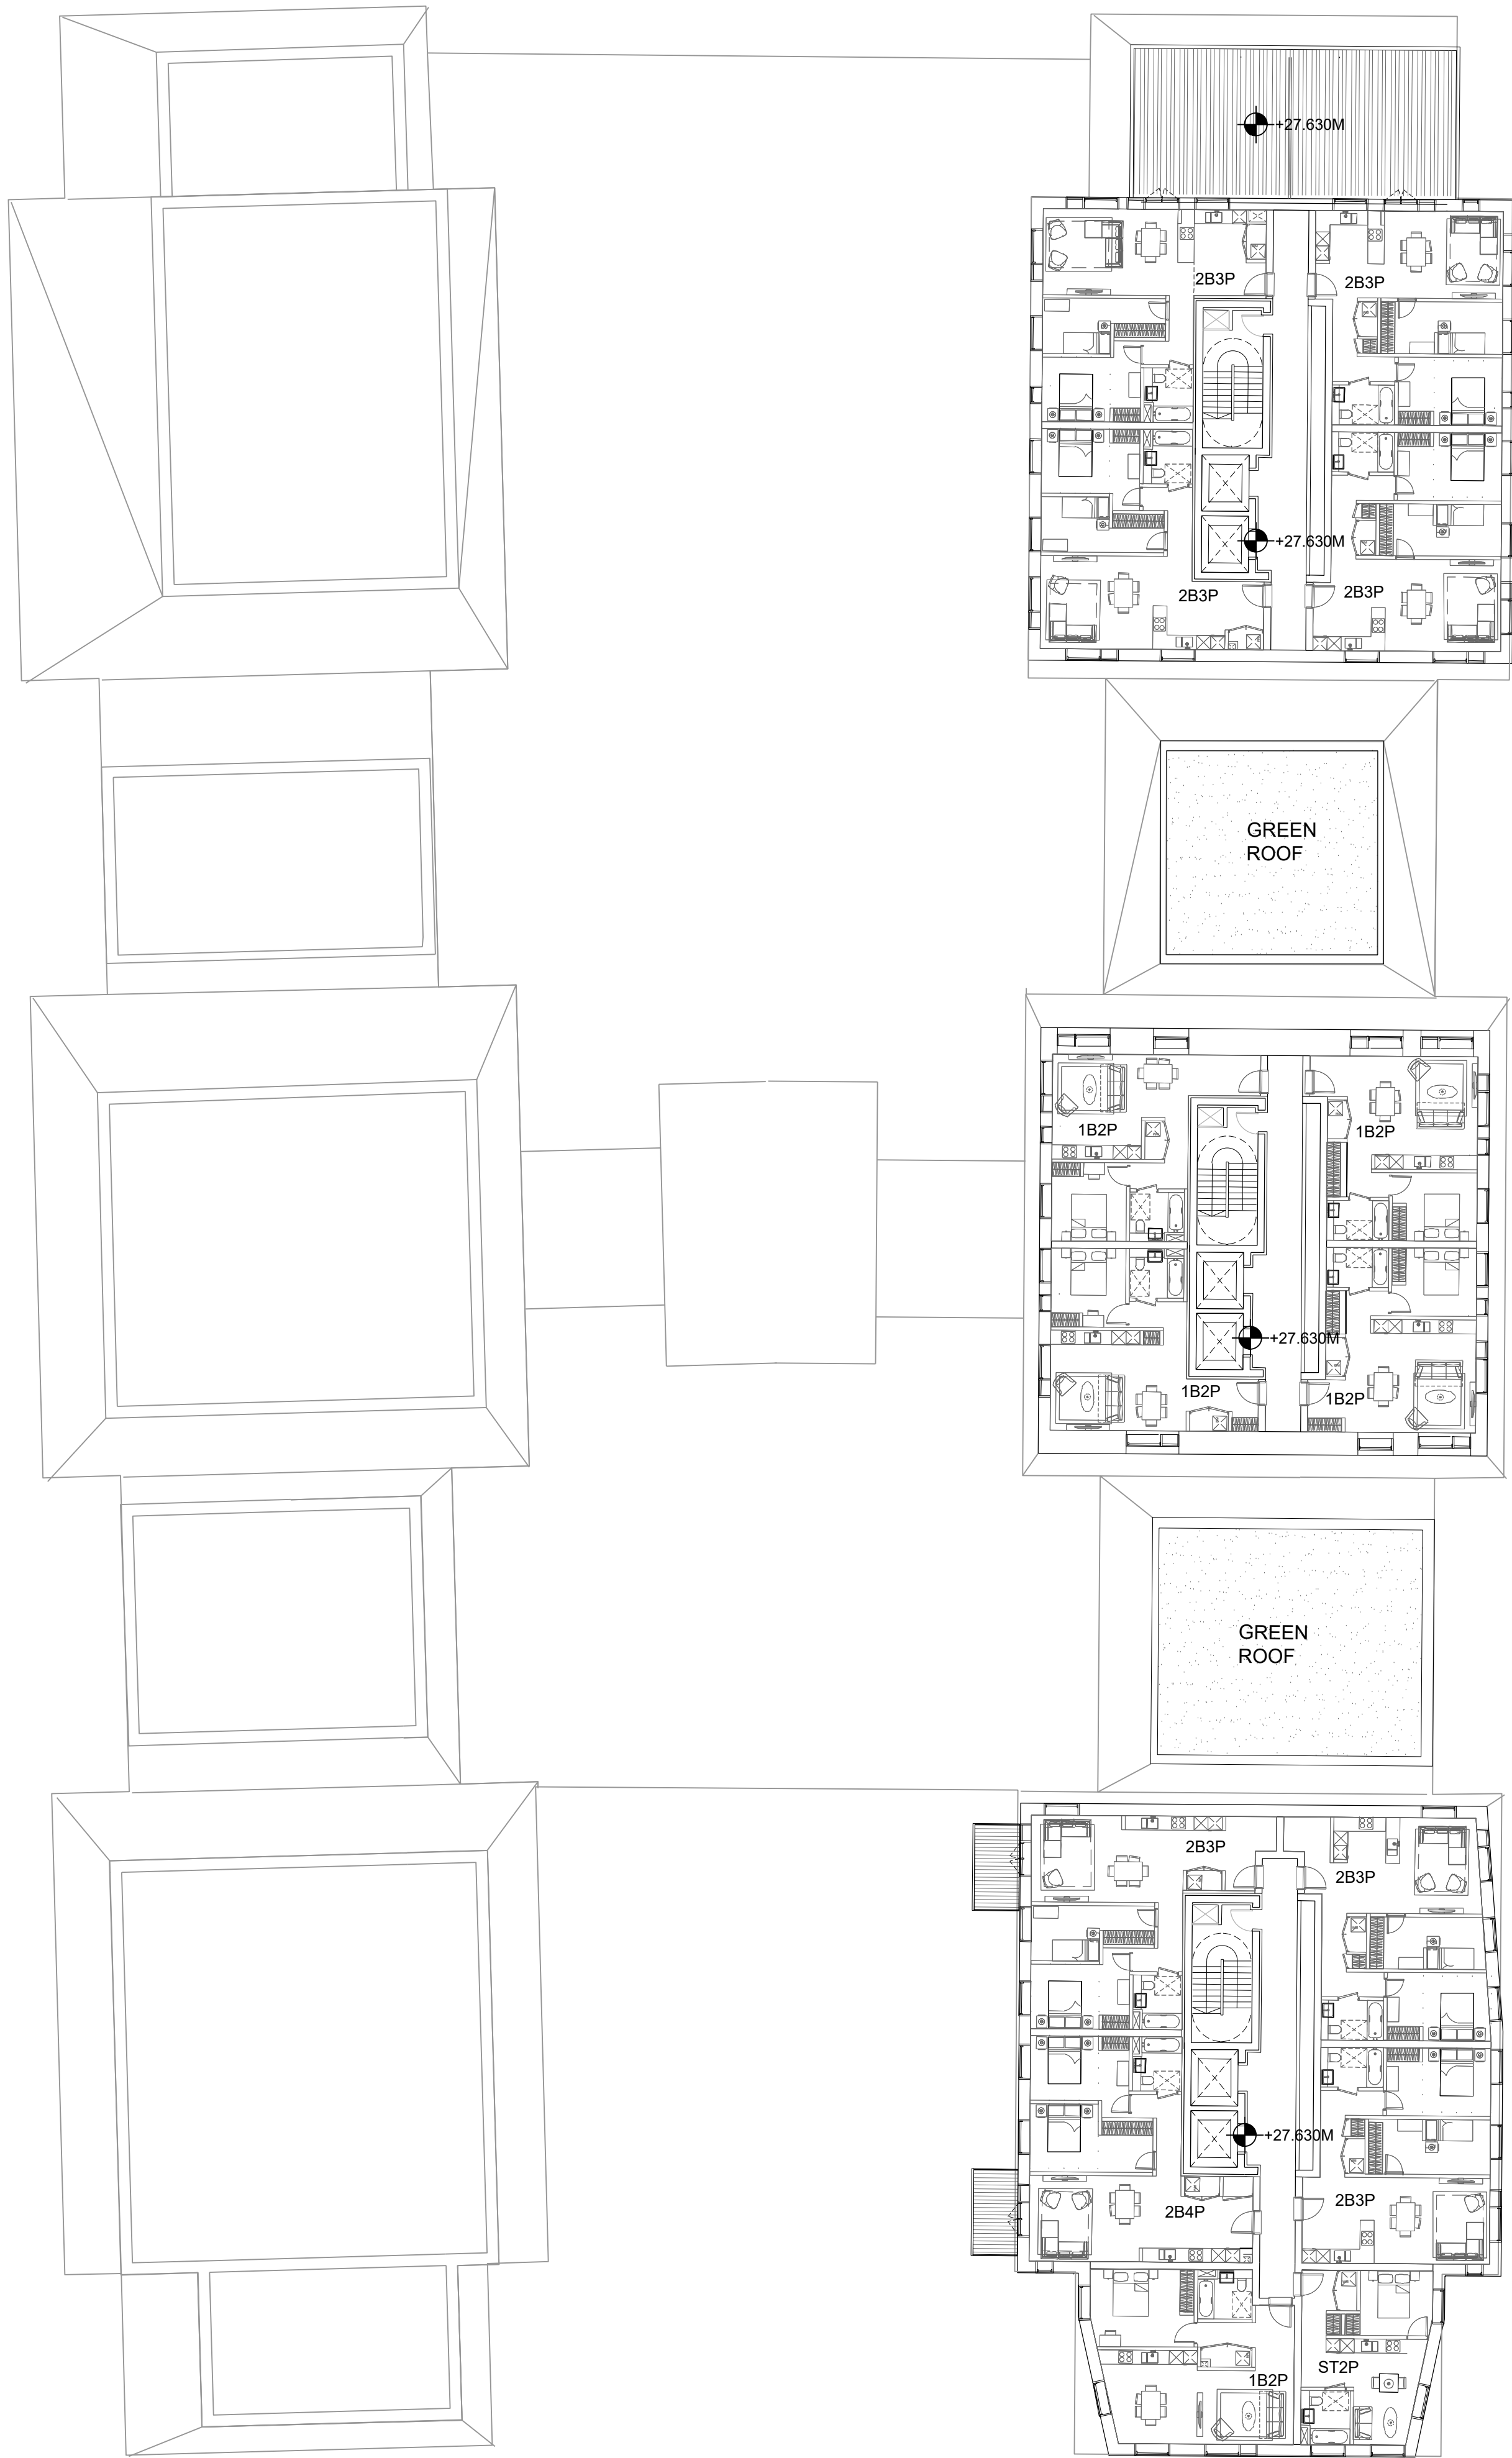

# KPF

**Client**  
Southwark GP Nominee 1 Ltd. and  
Southwark GP Nominee 2 Ltd.

**Structural Engineer**  
WSP  
Tel: 207 337 1700


**MEP Engineer**  
Hilson Moran  
Tel: 207 940 8888

**Landscape Consultant (Strategy)**  
Arup  
Tel: 207 636 1531

**Landscape Consultant (Design)**  
Andy Sturgeon  
Tel: 127 367 2575

**Structural Engineer (Building F)**  
AKT II  
Tel: 207 250 7777

| No. | Issue | Check | Date |
|-----|-------|-------|------|
|-----|-------|-------|------|

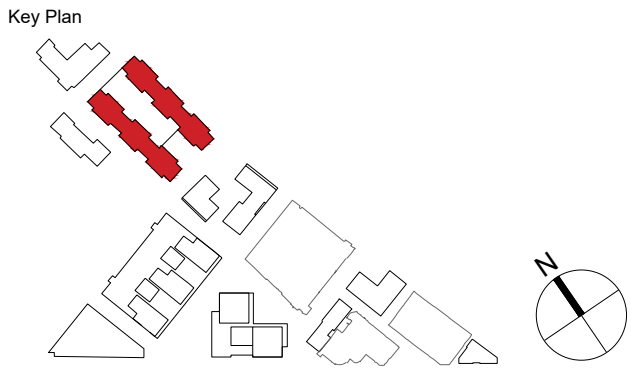

**Kohn Pedersen Fox Associates  
(International) PA**  
Architects and Planning Consultants

7a Langley Street  
London WC2H 9JA  
England  
T: +44 (0) 20 3119 5300  
F: +44 (0) 20 7497 1175  
<http://www.kpf.com>

| Proj. No. | Project            |
|-----------|--------------------|
| 2607      | Bermondsey Project |

| Scale      | Drawn by | Checked by |
|------------|----------|------------|
| 1:200 @ A1 | GG       |            |

Drawing Title and No.  
BC-1234  
LEVEL 07 FLOOR PLAN  
PROPOSED

| Drawing Ref.             | Rev. |
|--------------------------|------|
| 2607-KPF-BC03-07-DR-PLN- |      |

**A-0108** -