
 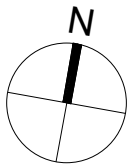



Filename: H:\2607_Project\Sunbeam\Drawings\CAD\Sheet\2607-KPF-BC03-08-DR-PLN-A-0109.dwg Plotted by: Grauvogel, Guillermo Plot Time: 10/20/2017 4:03 PM

1

BC-1234
LEVEL 08 FLOOR PLAN

SCALE: 1:200 @ A1

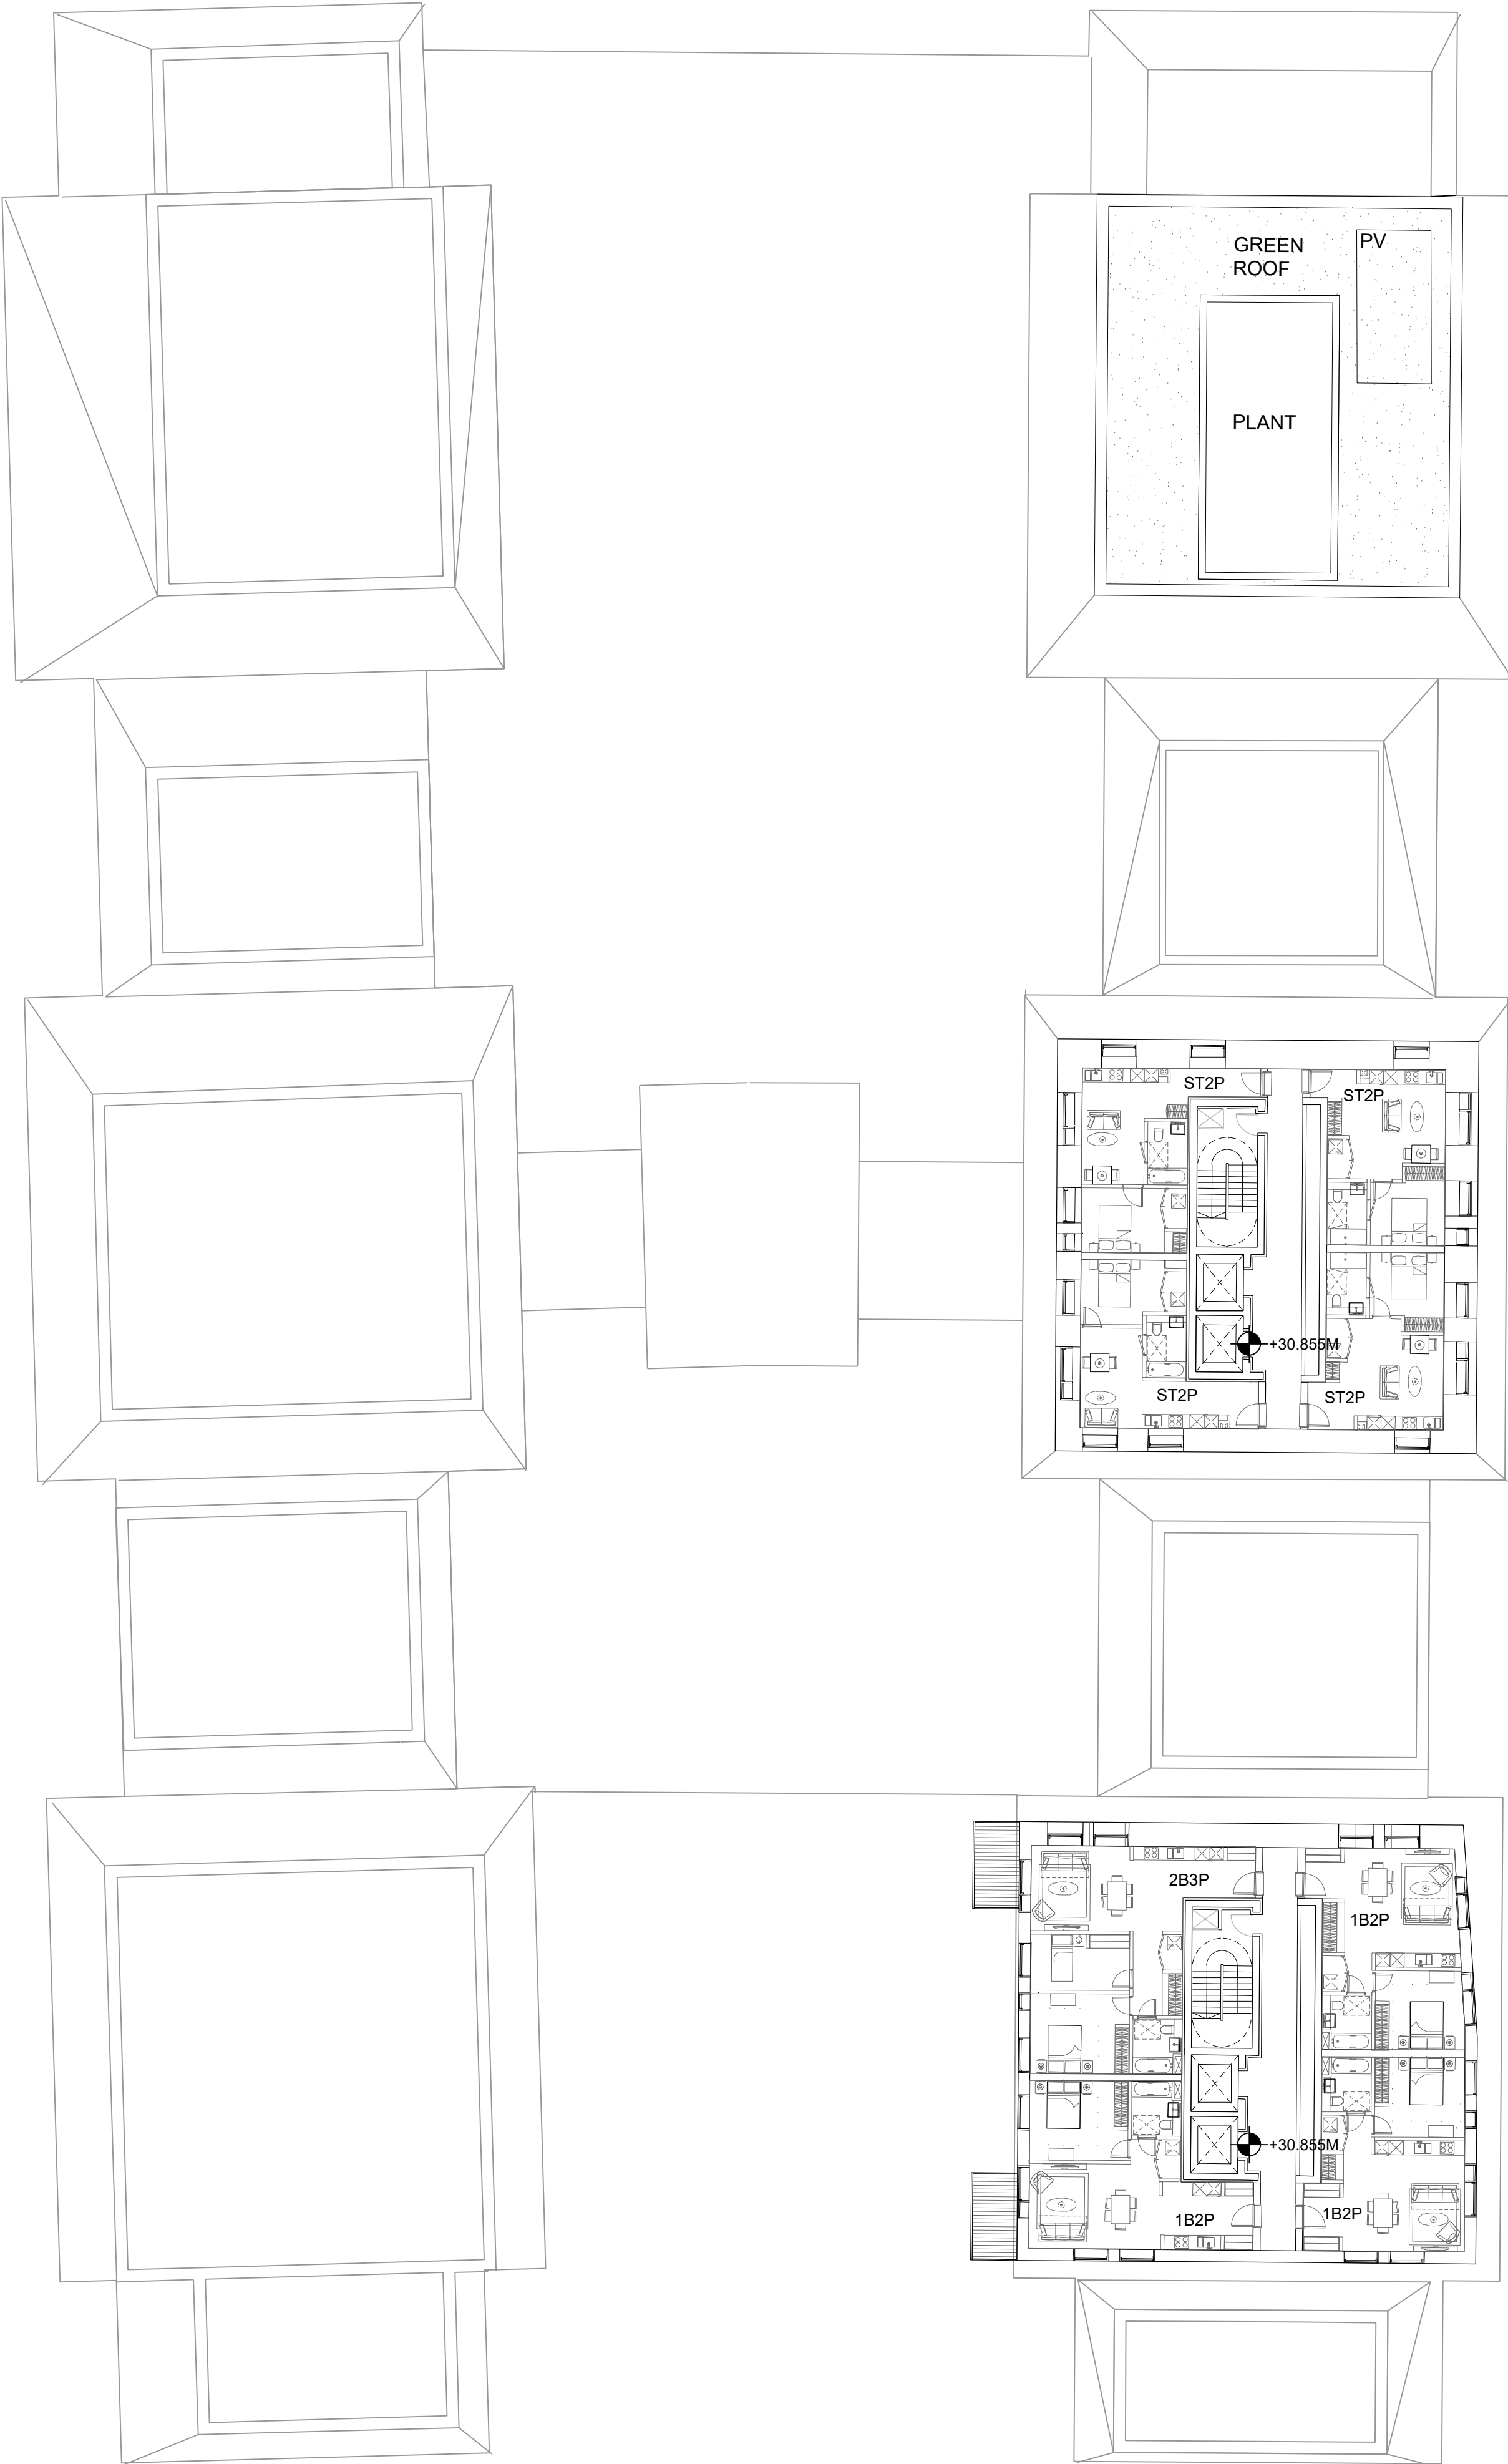

KPF

Client

Southwark GP Nominee 1 Ltd. and
Southwark GP Nominee 2 Ltd.

Structural Engineer

WSP
Tel: 207 337 1700

MEP Engineer

Hilson Moran
Tel: 207 940 8888

Landscape Consultant (Strategy)

Arup
Tel: 207 636 1531


Landscape Consultant (Design)

Andy Sturgeon
Tel: 127 367 2575

Structural Engineer (Building F)

AKT II
Tel: 207 250 7777

No.	Issue	Check	Date
-----	-------	-------	------

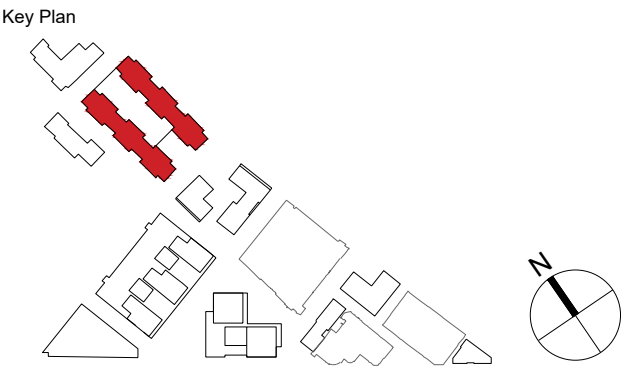

Kohn Pedersen Fox Associates

(International) PA
Architects and Planning Consultants

7a Langley Street
London WC2H 9JA
England
T: +44 (0) 20 3119 5300
F: +44 (0) 20 7497 1175
<http://www.kpf.com>

Proj. No. 2607 Project
Bermondsey Project

Scale 1:200 @ A1 Drawn by GG Checked by

Drawing Title and No.

BC-1234

LEVEL 08 FLOOR PLAN

PROPOSED

Drawing Ref. 2607-KPF-BC03-08-DR-PLN-

A-0109

Rev.

-