
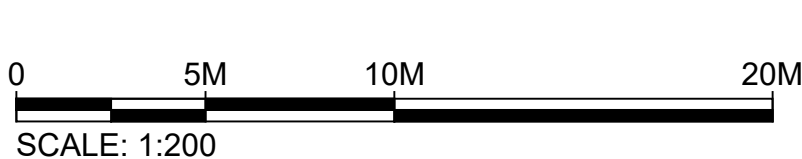


Filename: H:\2607_Project\Sunbeam\Drawings\CAD\Sheet\2607-KPF-BC03-RF-DR-PLN-A-0111.dwg Plotted by: Skop, Magdalena Plot Time: 5/3/2018 7:08 PM

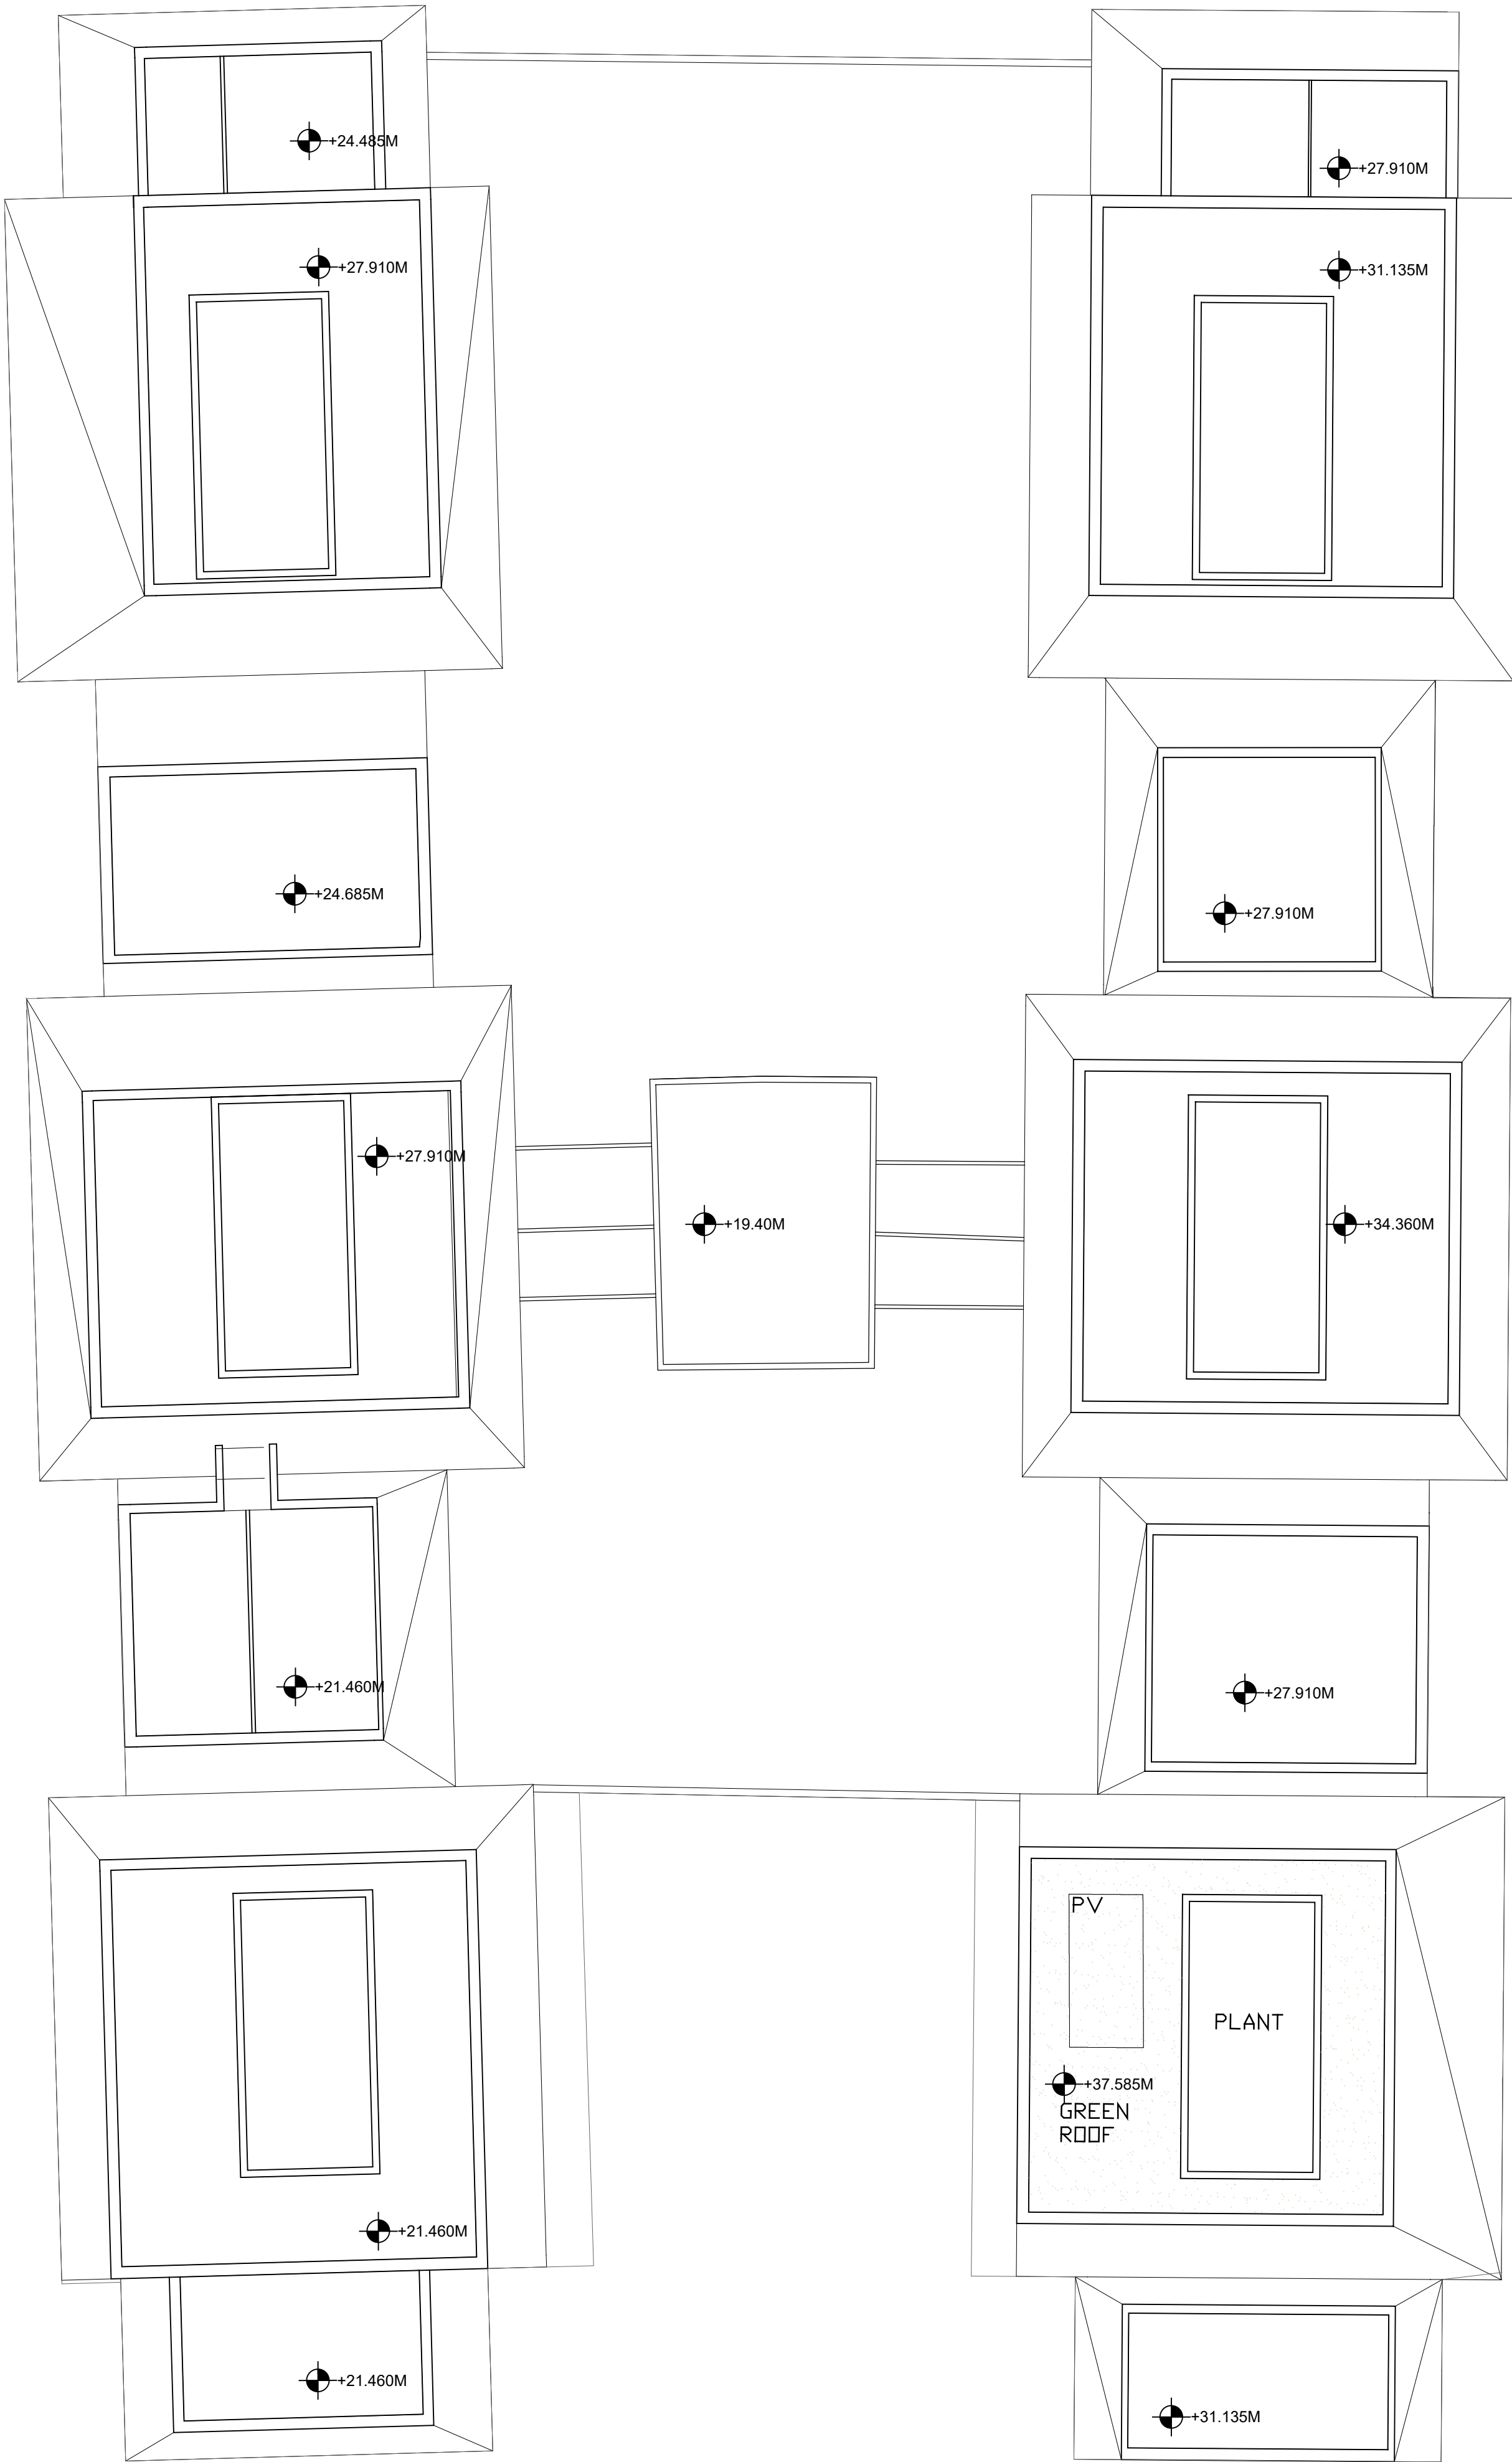

Client
Southwark GP Nominee 1 Ltd. and
Southwark GP Nominee 2 Ltd.

Structural Engineer
WSP
Tel: 207 337 1700

MEP Engineer
Hilson Moran
Tel: 207 940 8888


Landscape Consultant (Strategy)
Arup
Tel: 207 636 1531

Landscape Consultant (Design)
Andy Sturgeon
Tel: 127 367 2575

Structural Engineer (Building F)
AKT II
Tel: 207 250 7777

NOTE: THE DETAILED DESIGN OF THE RESIDENT'S
COMMUNAL GARDENS ARE SHOWN FOR ILLUSTRATIVE
PURPOSES ONLY

A		ADDENDUM		04.06.18	
No.	Issue	Check	Date		

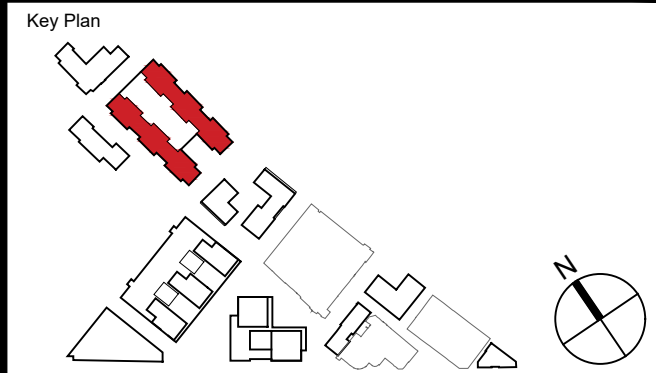

**Kohn Pedersen Fox Associates
(International) PA**
Architects and Planning Consultants

7a Langley Street
London WC2H 9JA
England
T: +44 (0) 20 3119 5300
F: +44 (0) 20 7497 1175
<http://www.kpf.com>

Proj. No. 2607 Project Bermondsey Project

Scale 1:200 @ A1 Drawn by GG Checked by

Drawing Title and No.
BC-1234
ROOF PLAN
PROPOSED

Drawing Ref. 2607-KPF-BC03-RF-DR-PLN-
A-0111 Rev. A