





Filename: H:\2607_Project\Sunbeam\Drawings\CAD\Sheet\2607-KPF-BF07-RF-DR-PLN-A-0113.dwg Plotted by: Asciglu Bekir Plot Time: 9/11/2019 5:54 PM

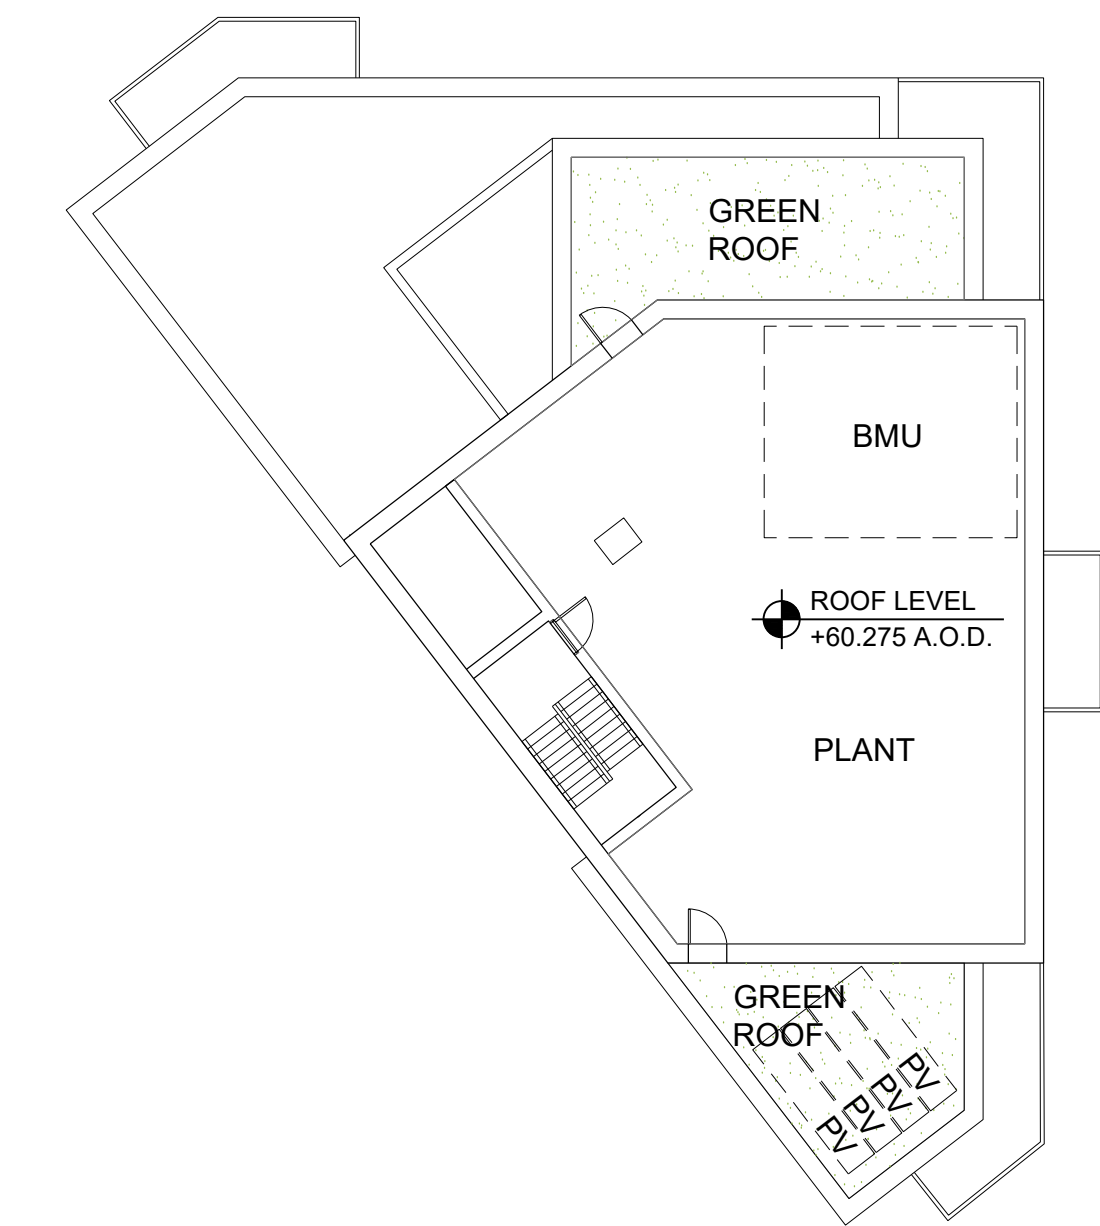

1
BF-W
ROOF LEVEL PLAN
SCALE: 1:200 @ A1

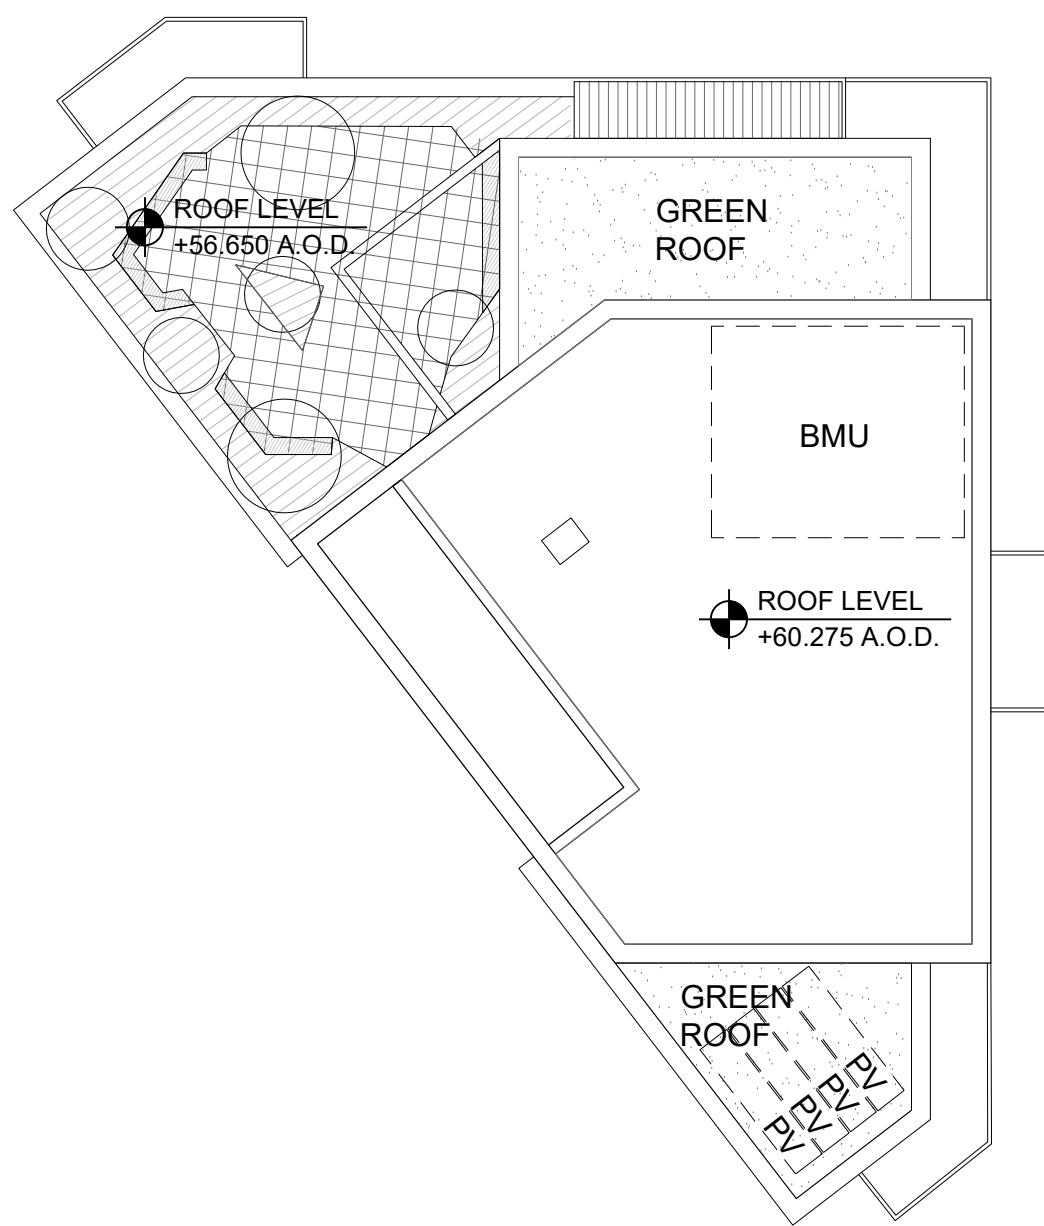

 2
BF-W
UPPER ROOF PLAN
SCALE: 1:200 @ A1

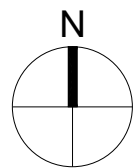

KPF

Client

Southwark GP Nominee 1 Ltd. and
Southwark GP Nominee 2 Ltd.

Structural Engineer

WSP
Tel: 020 7337 1700

MEP Engineer

Hilson Moran
Tel: 020 7940 8888

Landscape Consultant (Strategy)

Arup
Tel: 020 7636 1531


Landscape Consultant (Design)

Andy Sturgeon
Tel: 012 7367 2575

Structural Engineer (Building F)

AKT II
Tel: 020 7250 7777

B	AMENDED PROPOSALS	16.09.19
A	ADDENDUM	19.01.18
No.	Issue	Check Date

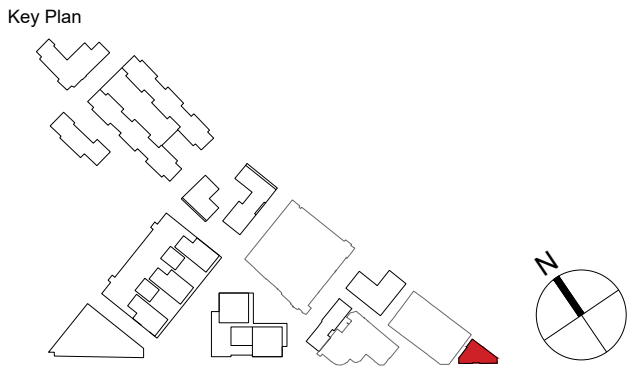

**Kohn Pedersen Fox Associates
(International) PA**
Architects and Planning Consultants

7a Langley Street
London WC2H 9JA
England
T: +44 (0) 20 3119 5300
F: +44 (0) 20 7497 1175
<http://www.kpf.com>

Proj. No. Project
2607 Bermondsey Project

Scale Drawn by Checked by
1:200 @ A1 AH

Drawing Title and No.
BF-W
ROOF LEVEL PLAN & UPPER ROOF PLAN
PROPOSED

Drawing Ref. Rev.
2607-KPF-BF07-RF-DR-PLN-
A-0113 B