


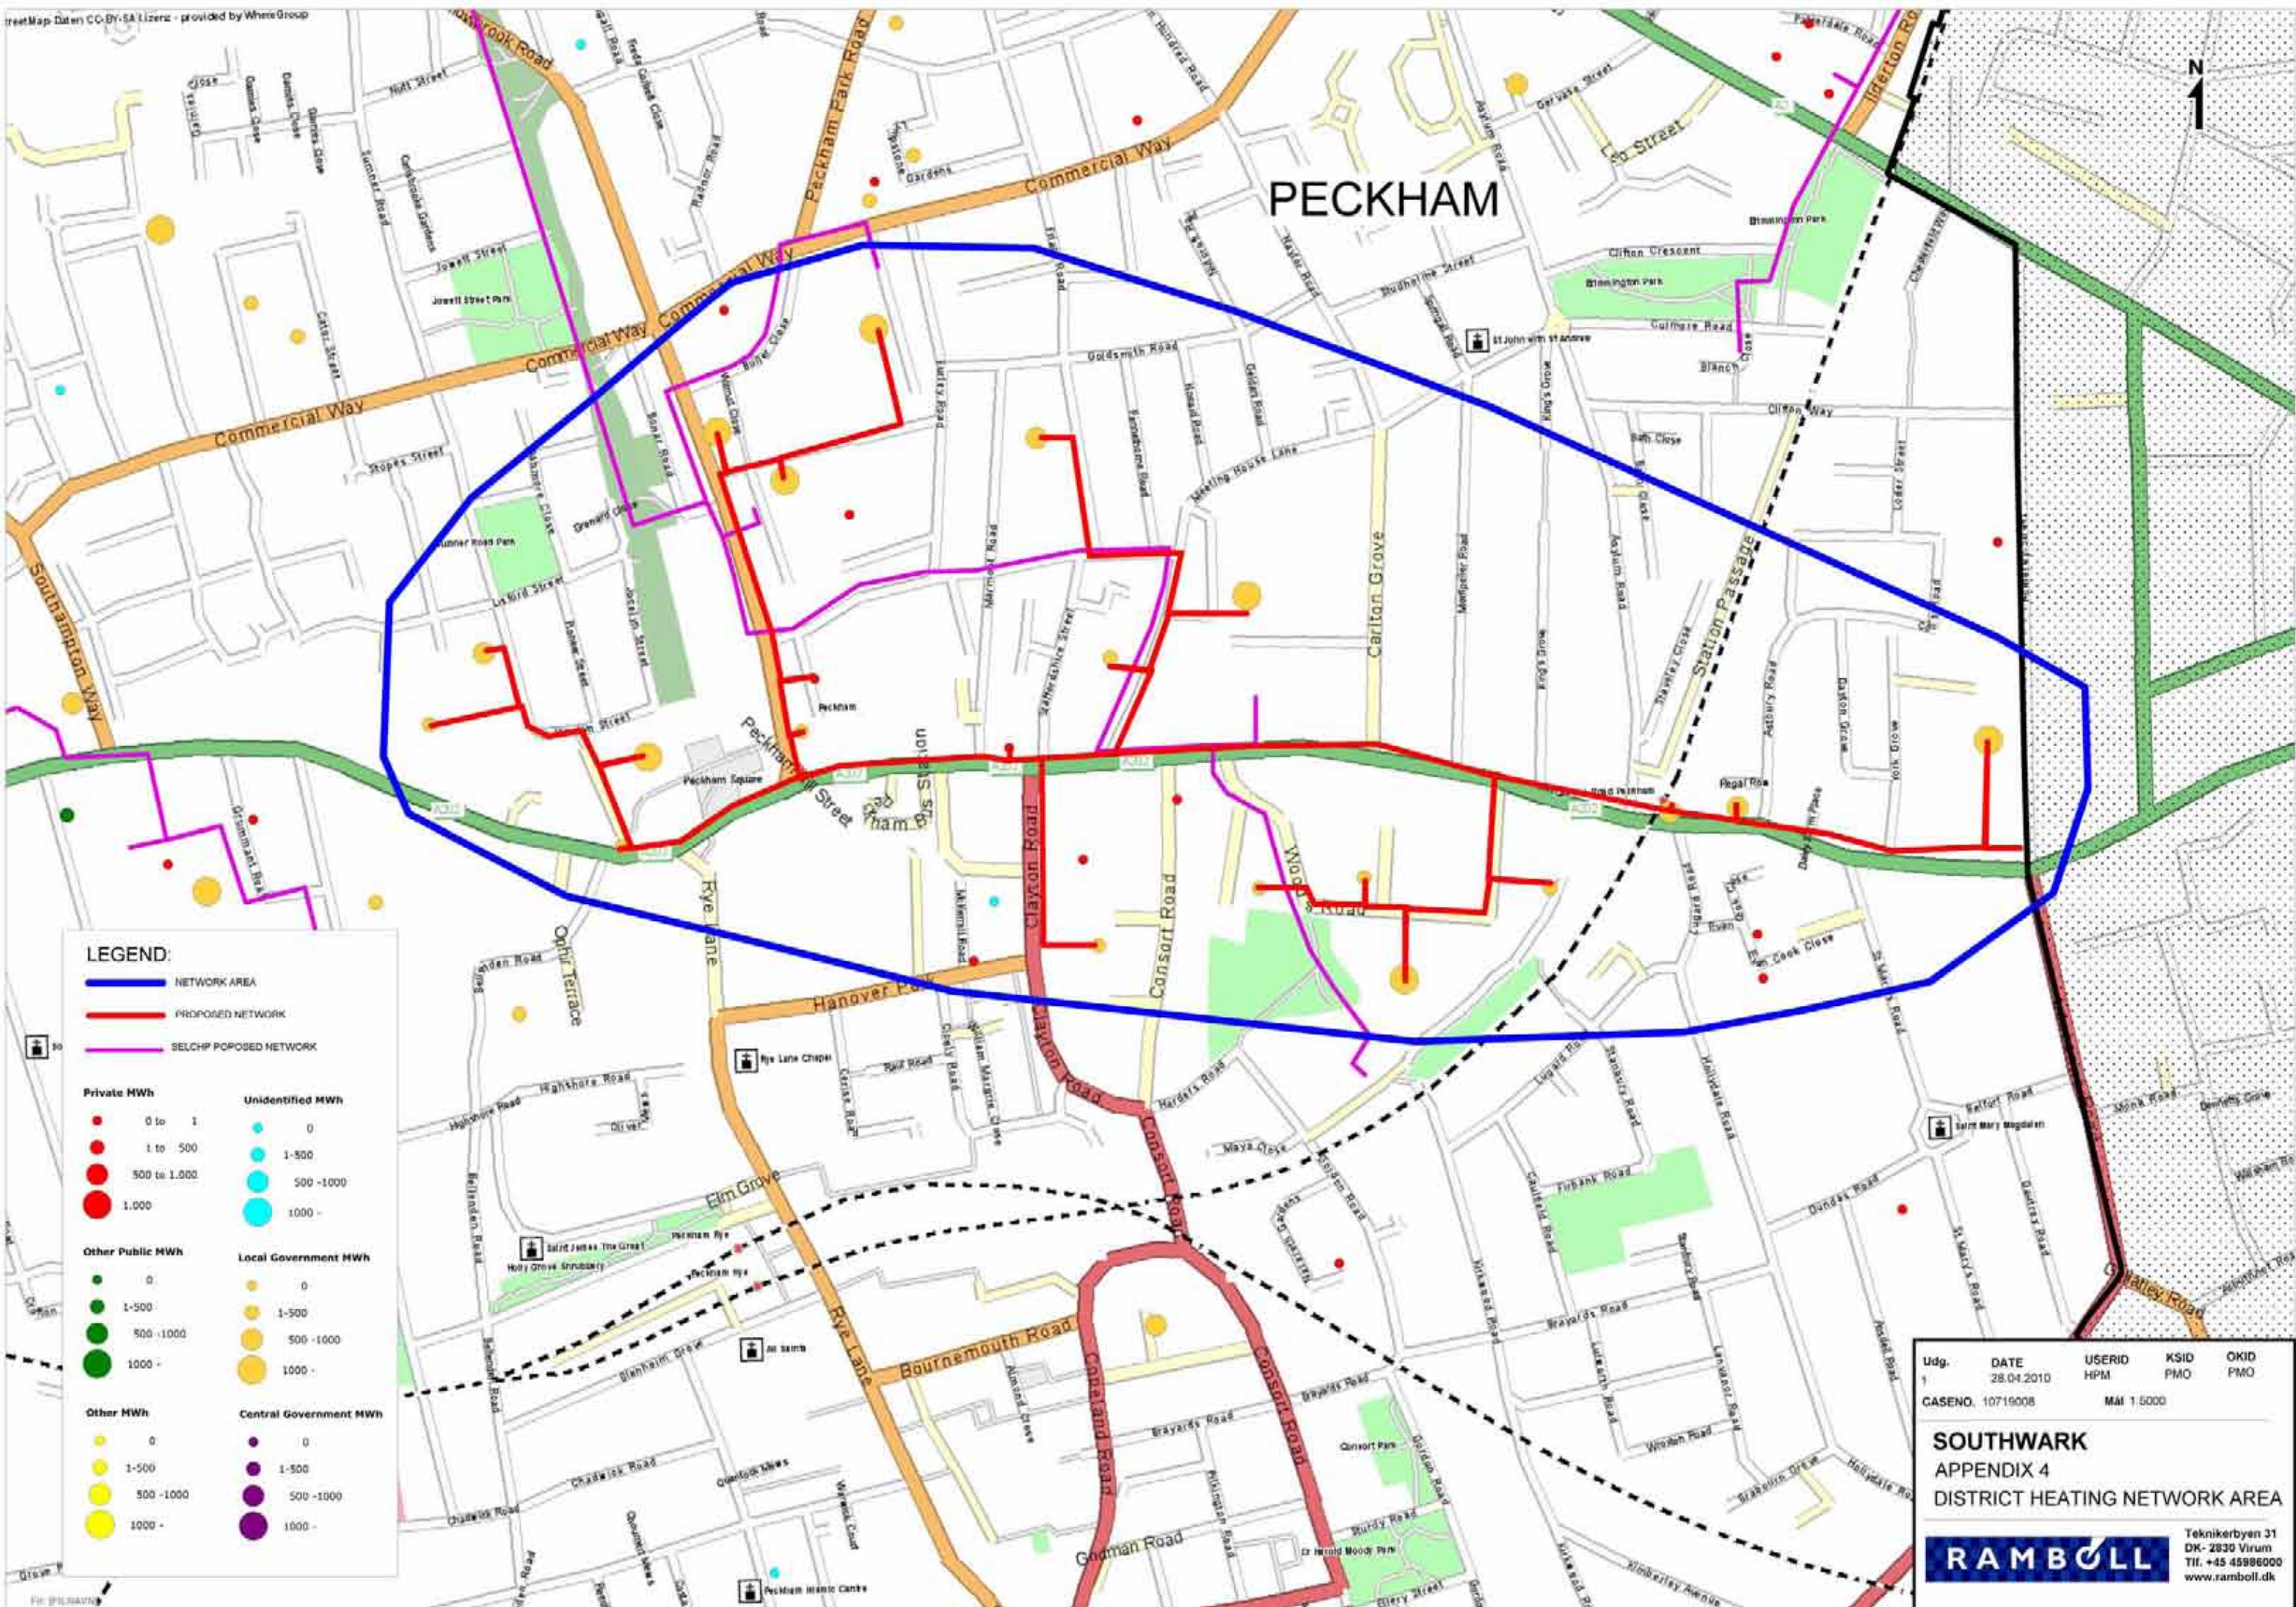


Udg. 1
DATE 28.04.2010
USERID HPM
KSID PMO
OKID PMO
CASENO. 10719008
MÅL 1:5000

SOUTHWARK
APPENDIX 4
DISTRICT HEATING NETWORK AREA

RAMBOLL

Teknikerbyen 31
DK- 2830 Virum
Tlf. +45 45986000
www.ramboll.dk

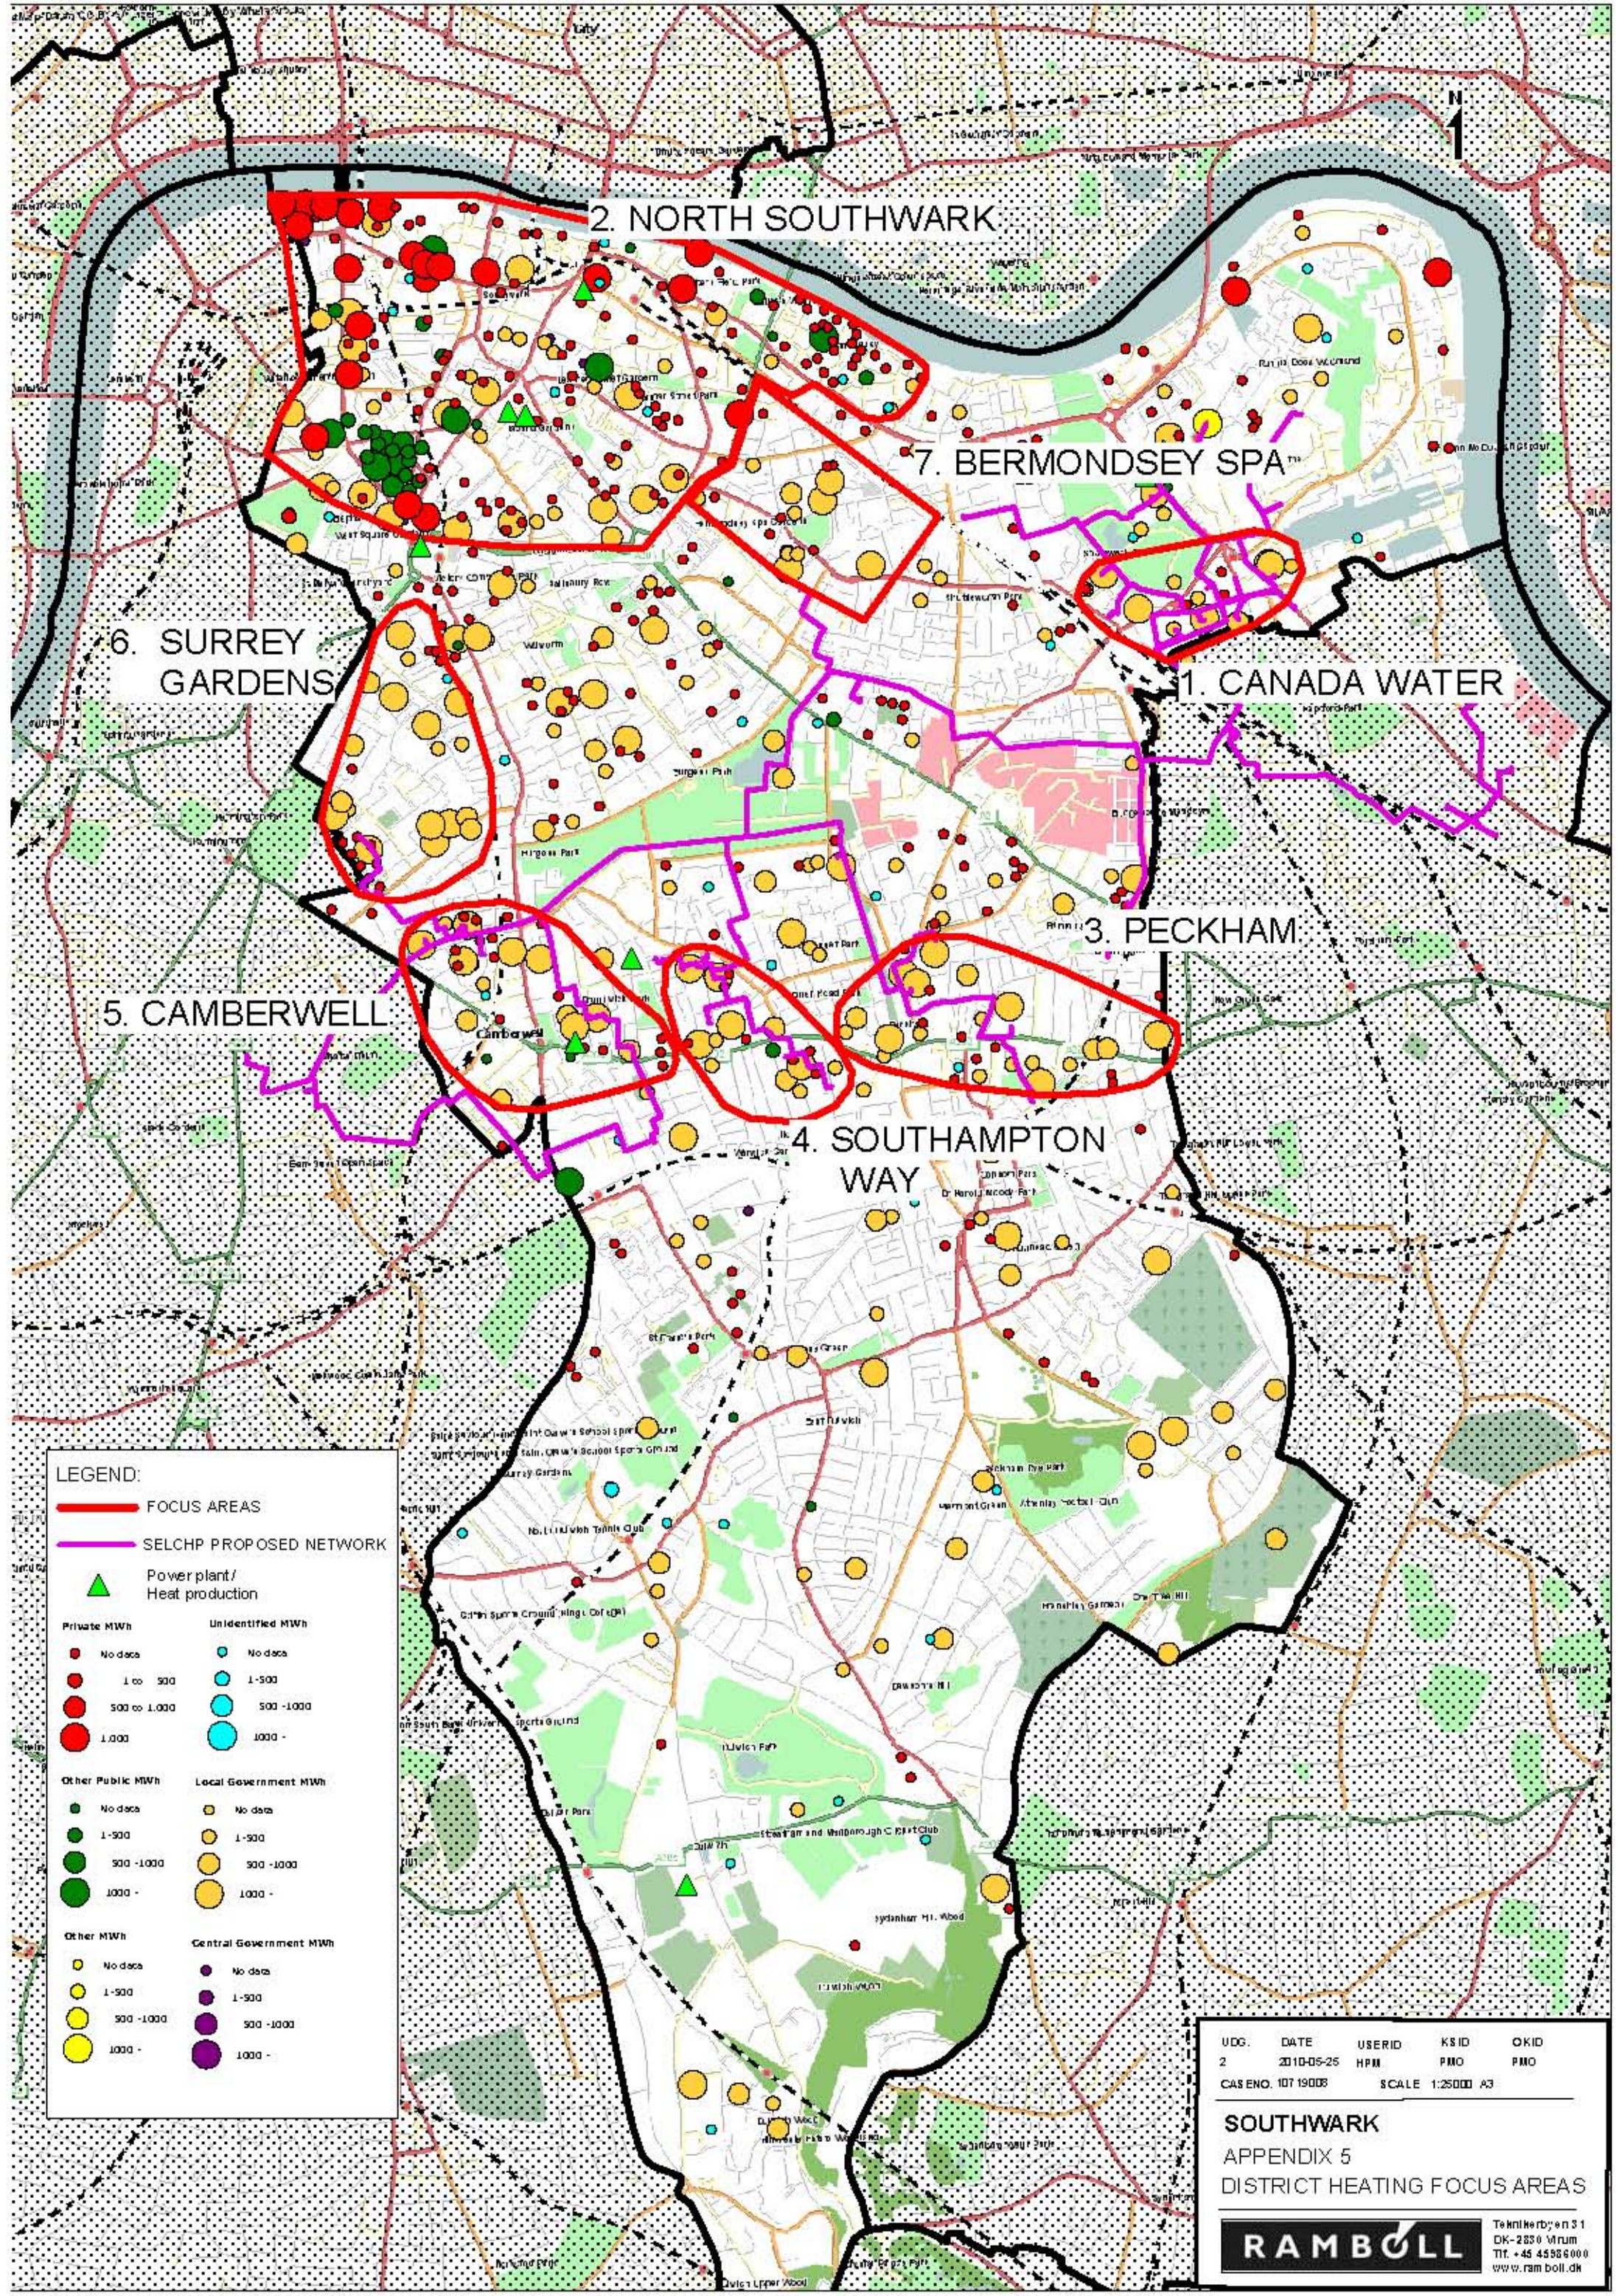

2. NORTH SOUTHWARK

7. BERMONDSEY SPA

6. SURREY GARDENS

1. CANADA WATER

5. CAMBERWELL

3. PECKHAM

4. SOUTHAMPTON WAY

LEGEND:

- FOCUS AREAS
- SELCHP PROPOSED NETWORK
- Power plant/
Heat production

Private MWh	Unidentified MWh
No data	No data
1 to 500	1-500
500 to 1,000	500-1,000
1,000	1,000 -

Other Public MWh	Local Government MWh
No data	No data
1-500	1-500
500-1,000	500-1,000
1,000 -	1,000 -

Other MWh	Central Government MWh
No data	No data
1-500	1-500
500-1,000	500-1,000
1,000 -	1,000 -

UDG.	DATE	USERID	KSID	OKID
2	2010-05-25	HPM	PMO	PMO
CASE NO. 10719008		SCALE 1:25000 A3		

SOUTHWARK
APPENDIX 5
DISTRICT HEATING FOCUS AREAS

RAMBOLL

Teknikerbyen 31
DK-2850 Virum
Tlf. +45 4458 6000
www.ramboll.dk

