



Building 7 Indicative Roof Plant Layout

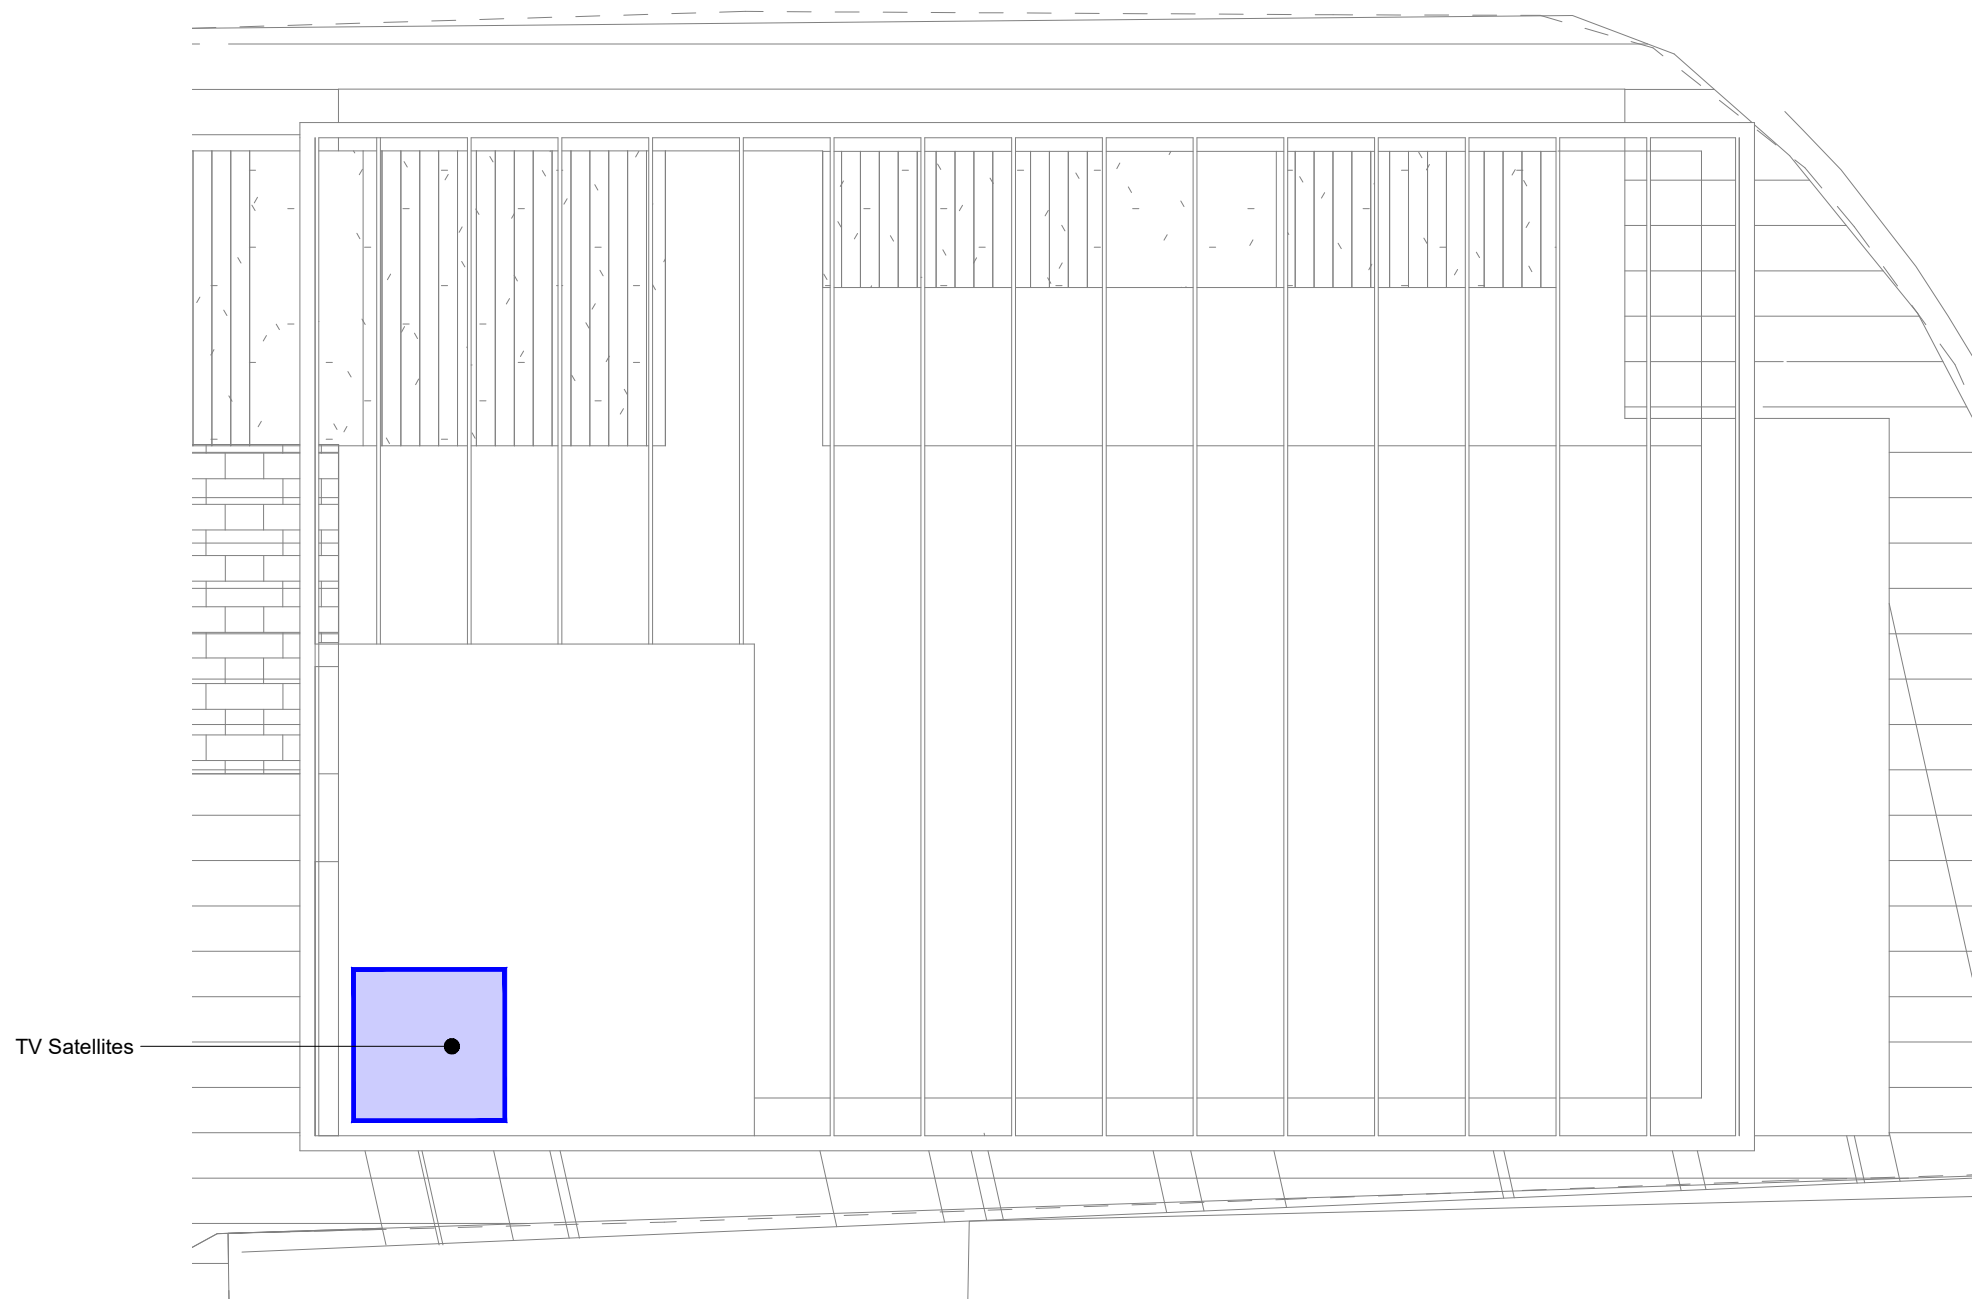

Building 6 Indicative Roof Plant Layout

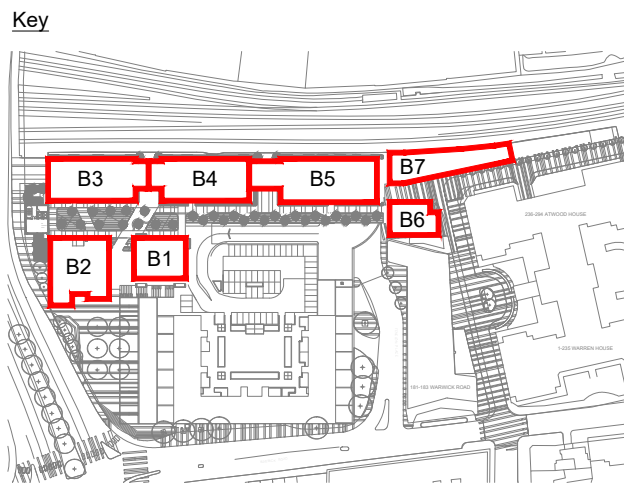

02/01/2019	Stage 2 Issue	MW SB
Rev Date	Description	Cast Chk

Architect
JOHN McASLAN + PARTNERS

Client
LONDONNEWCASTLE

Project
West Cromwell Road

Drawing Title
**MEP Services
Buildings 6 and 7
Indicative Roof Plant Layouts**

ScotchPartners

Building Services Engineering | Sustainability | Acoustics

Stripler Court
137 Farringdon Road
London EC1R 3AD

020 3544 5400
www.scotchpartners.com

Copyright reserved. Work is signed dimensions only. Discrepancies to be reported before proceeding.

Issue	Stage 2
Date	Aug 18
Scale	@ A1 1:100
Drawn By	LB
Checked By	SB
Drawing No.	5171-SP-MEP-902